



## 1 WEST ELEVATION

A3 SCALE: 1/8" = 1'-0"

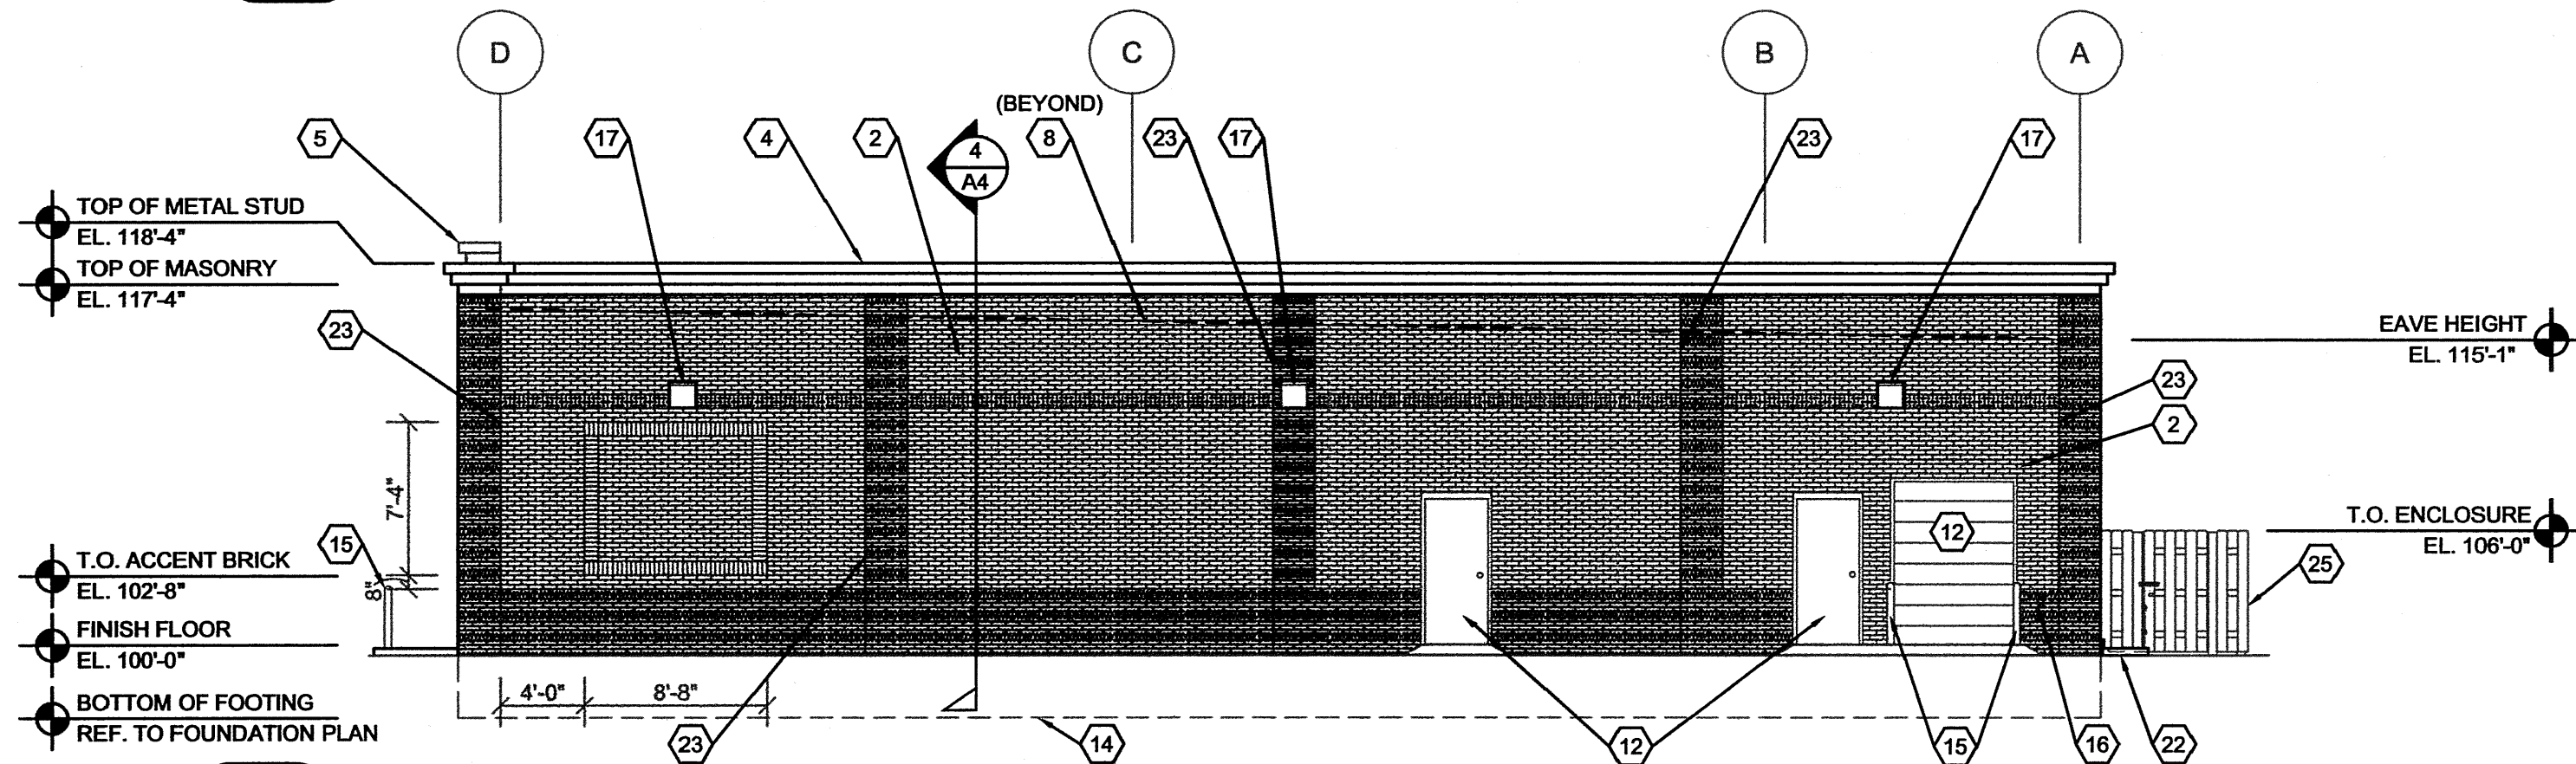


## 2 SOUTH ELEVATION

A3 SCALE: 1/8" = 1'-0"

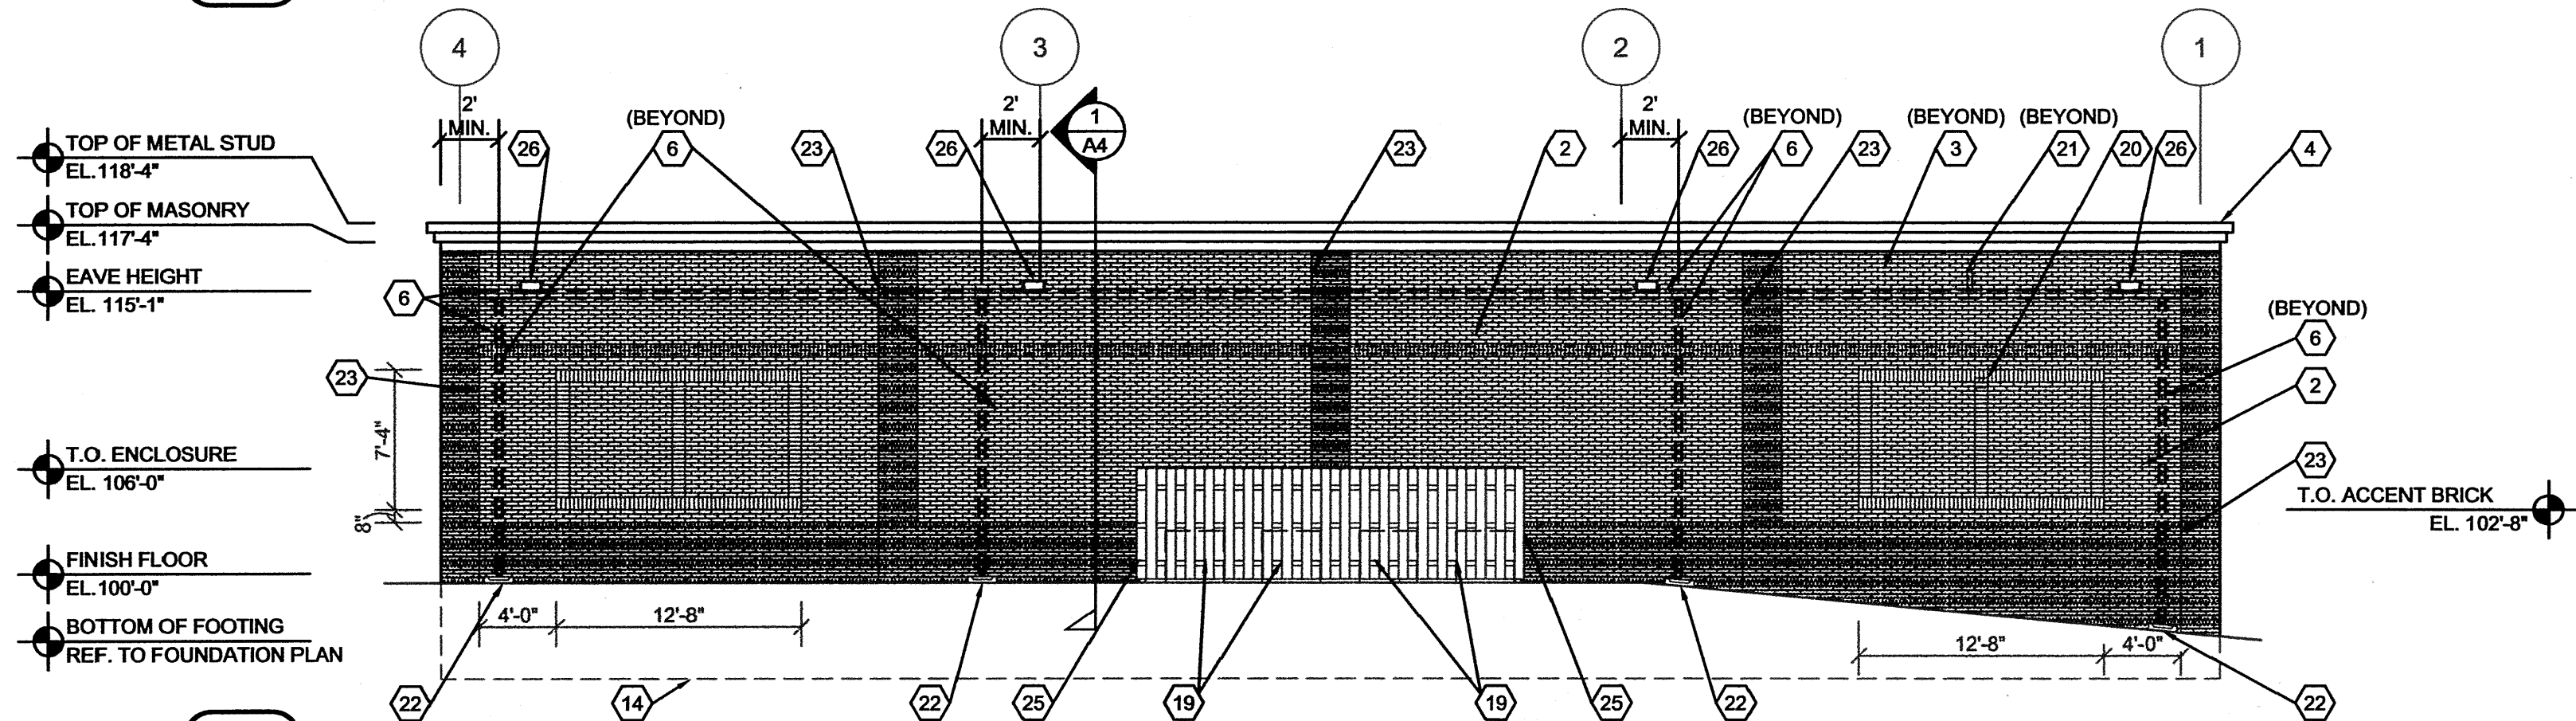


## 3 EAST ELEVATION

A3 SCALE: 1/8" = 1'-0"

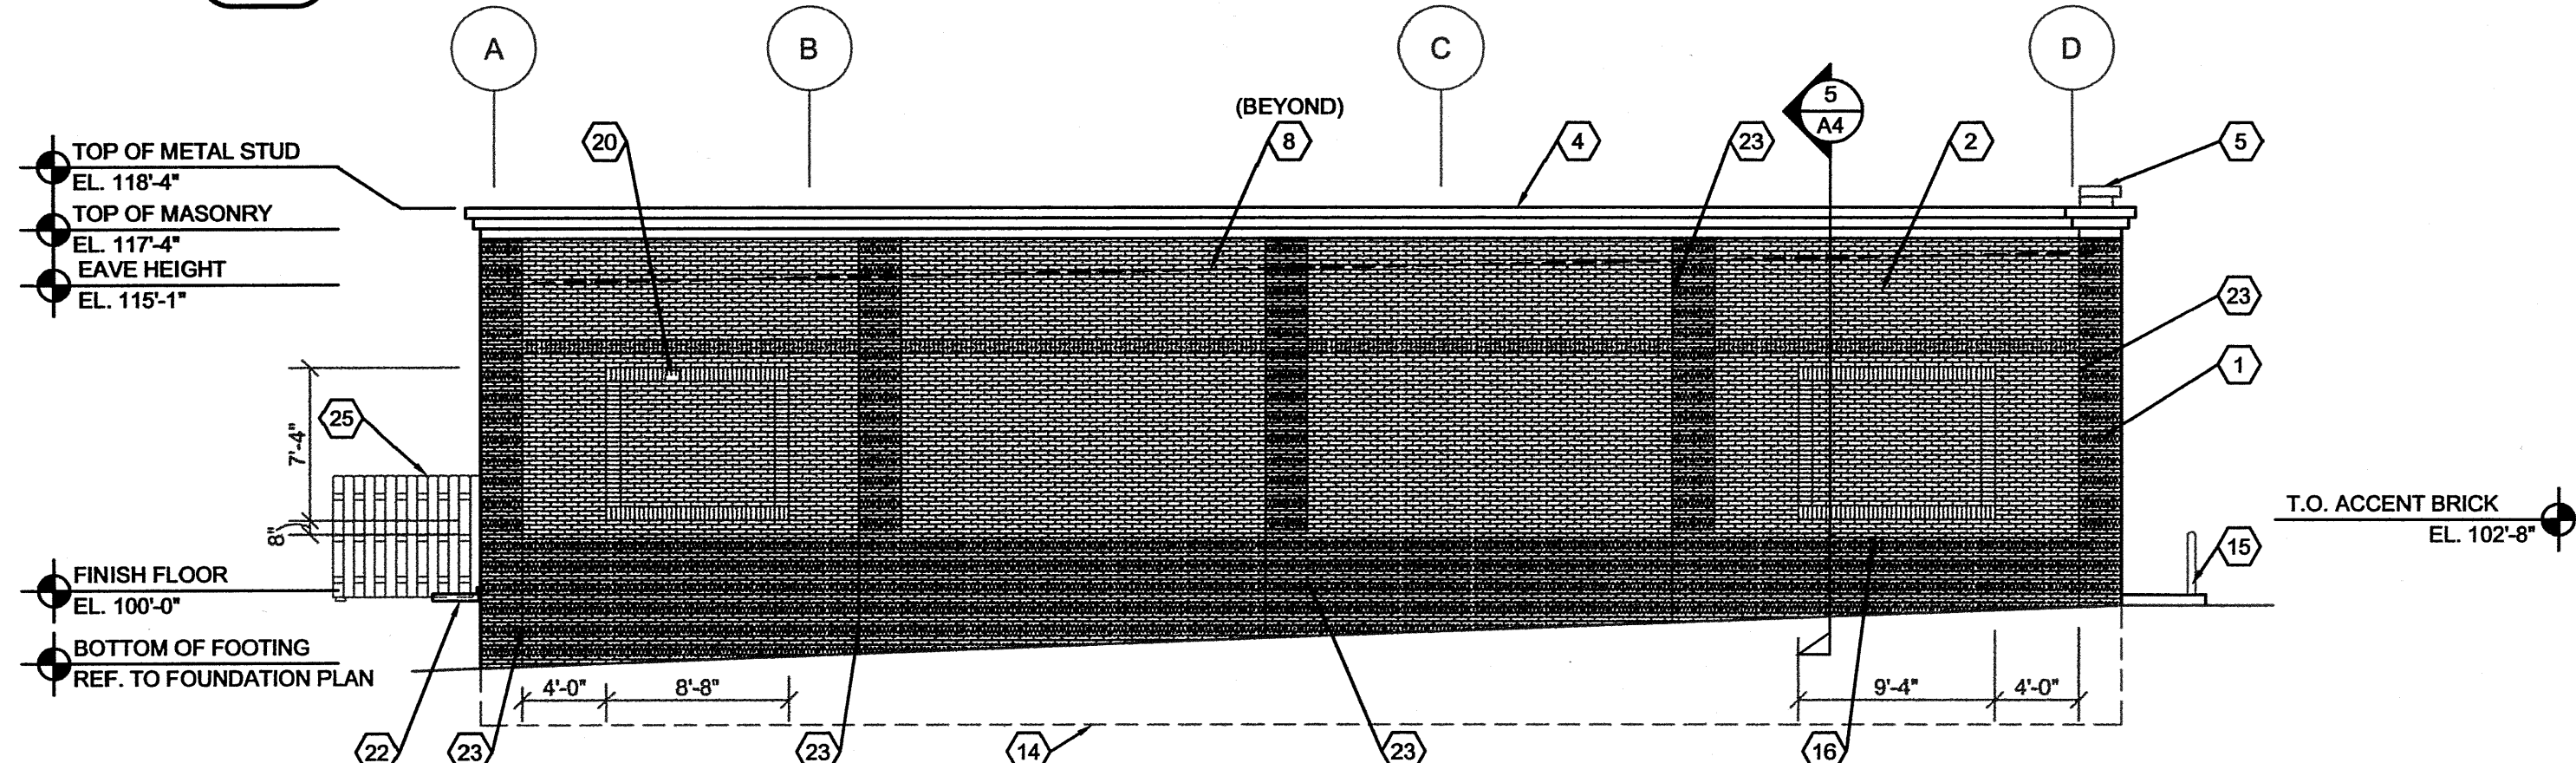


## 4 NORTH ELEVATION

A3 SCALE: 1/8" = 1'-0"

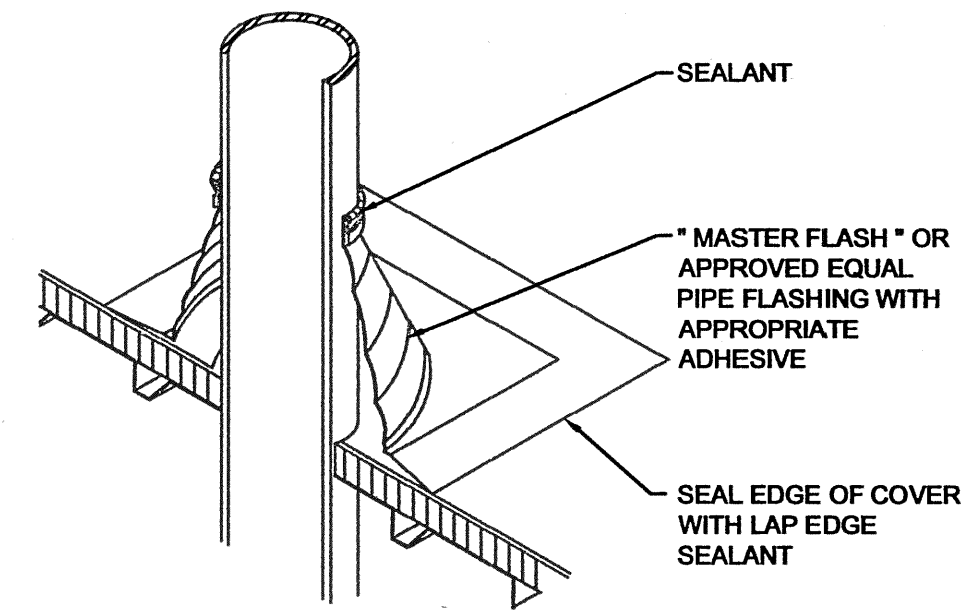


## 5 VENT PIPE

A3 SCALE: N.T.S.

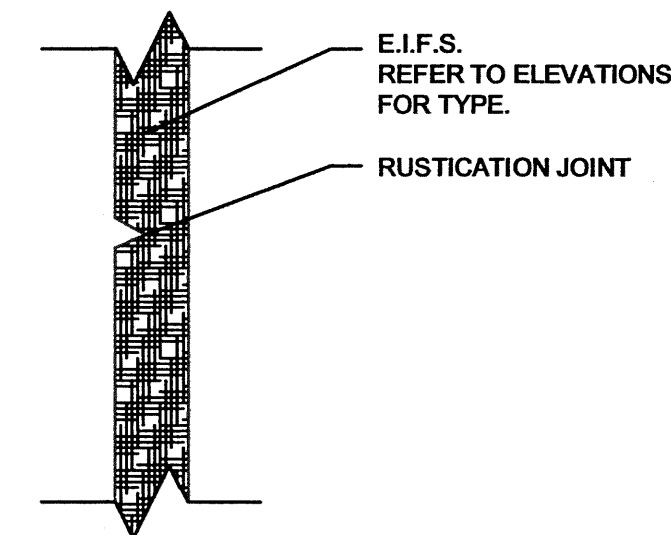

## 6 JOINT DETAIL

A3 SCALE: N.T.S.

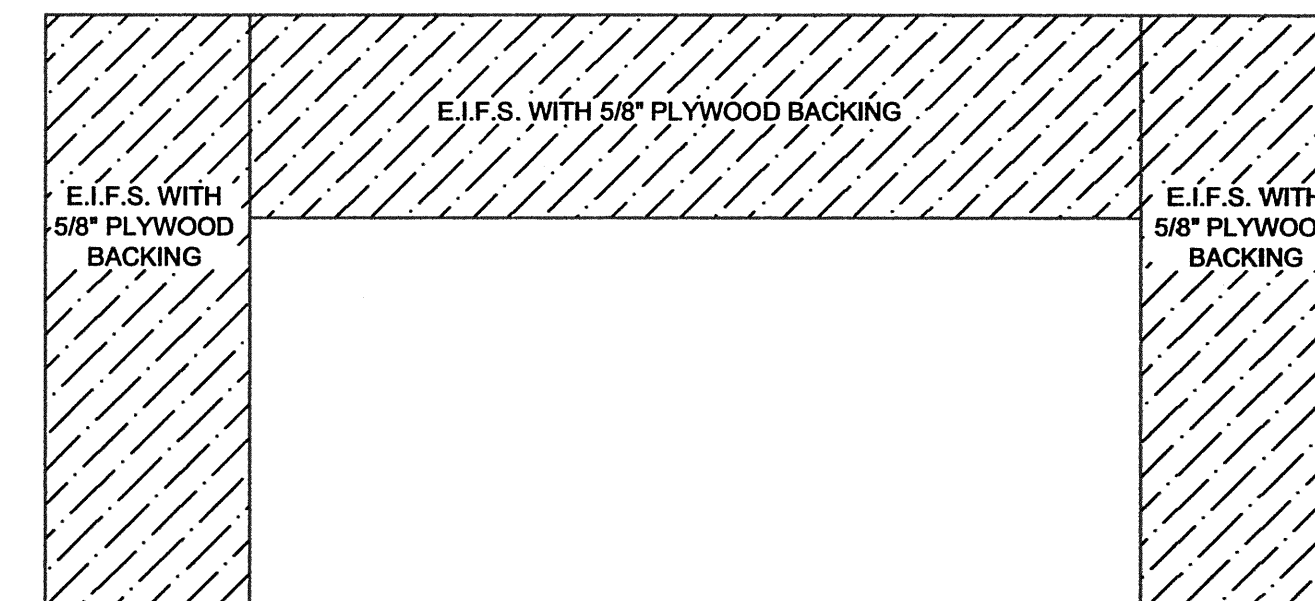

## 7 E.I.F.S. BACKING

A3 SCALE: N.T.S.

## EXTERIOR FINISH SCHEDULE

TYPE:	COMPANY TYPE:	SPECS:
BRICK	ACME BRICK (OR APPROVED EQUAL)	FIELD BRICK COLOR: BL 30 DOVE GREY MORTAR COLOR: MATCH BRICK COLOR SIZE: MODULAR COURSING: RUNNING (ACCEPT WHERE SHOWN TO BE SOLDIER COURSING)  ACCENT BRICK COLOR: BL 600 OXFORD BROWN (INDICATED BY SHADING: [Pattern])
EXTERIOR INSULATION AND FINISH SYSTEM (E.I.F.S.)	DRYVIT SANDBLAST FINISH	CUSTOM COLOR O'REILLY RED # ST184-83-01 (FACTORY MIXED ONLY)
STOREFRONT (NO SUBSTITUTES)	EFCO KAWNEER VISTA WALL	COLOR: IVY DARK IVY INTERSTATE GREEN O'REILLY GREEN GLIDDEN EXTERIOR SEMI-GLOSS LATEX BASE: 2407 - 500 YOK: 3P-42 TBL: 4P48 GRN: 3P14 WHT: 2P COLOR #: CUSTOM
BOLLARDS OVERHEAD DOOR	IN FIELD	O'REILLY GREEN GLIDDEN EXTERIOR SEMI-GLOSS LATEX BASE: 2407 - 500 YOK: 3P-42 TBL: 4P48 GRN: 3P14 WHT: 2P COLOR #: CUSTOM
EXTERIOR DOORS	OWNER	OWNER
SHEET METAL CAP FLASHING AT E.I.F.S.	BY METAL BUILDING MFG'R.	O'REILLY RED SHERWIN WILLIAMS MIX BASE-B65R338-B60V30- GALLON FORMULA QV-45 TW-15 CLEAR COAT-DIAMOND CLAD CLEAR COAT URETHANE B65T105/B65V105/B65C105- 3 COMPONENT
PRE - FINISHED SHEET METAL CAP FLASHING	BY METAL BUILDING MFG'R.	TOP AND BOTTOM COLOR TO MATCH FIELD BRICK COLOR, MIDDLE COLOR TO MATCH ACCENT BRICK.

## GENERAL NOTES:

- REFER TO PROJECT MANUAL FOR ADDITIONAL REQUIREMENTS.
- REFER TO COVER SHEET FOR BUILDING DESIGN CRITERIA.
- REFER TO PRE-ENGINEERED METAL BUILDING DRAWINGS FOR ADDITIONAL REQUIREMENTS.
- REFER TO MECHANICAL / ELECTRICAL PLAN FOR SYSTEM TYPES AND LOCATIONS.
- REFER TO SITE DEVELOPMENT PLANS FOR ADDITIONAL REQUIREMENTS.

## KEY NOTES:

- EXTERIOR INSULATION AND FINISH SYSTEM (E.I.F.S.): REFER TO EXTERIOR FINISH SCHEDULE.
- MASONRY WALL CONSTRUCTION: REFER TO EXTERIOR FINISH SCHEDULE.
- PRE-FINISHED STANDING SEAM ROOF: BY PRE-ENGINEERED METAL BUILDING COMPANY.
- 3 TIER METAL CAP FLASHING TO BE FIELD FABRICATED: FIELD PAINTED FLAT STOCK PROVIDED BY BUTLER MFG. TOP AND BOTTOM COLOR TO MATCH FIELD BRICK COLOR, MIDDLE COLOR TO MATCH ACCENT BRICK.
- 3 TIER METAL CAP FLASHING TO BE FIELD FABRICATED: FIELD PAINTED FLAT STOCK PROVIDED BY BUTLER MFG. COLOR TO MATCH E.I.F.S.
- PRE - ENGINEERED INTERNAL METAL GUTTER PER METAL BUILDING MANUFACTURER AND 6" PVC D.S. (BY CONTRACTOR).
- NOT USED.
- LINE OF ROOF: DASHED LINE INDICATES LINE OF ROOF BEYOND WITH SLOPE OF 1/4" PER FOOT.
- SIGN: APPROXIMATE OUTLINE OF "O'REILLY AUTO PARTS" SIGN. OWNER FURNISHED AND INSTALLED. PROVIDE BLOCKING AS REQUIRED FOR MOUNTING SIGN. WORK TO COORDINATED WITH OWNER.
- ADDRESS NUMBERS: 6" VINYL BY CONTRACTOR. COLOR TO BE WHITE.
- NOT USED.
- DOOR AND FRAME: FIELD PAINT DOOR TO MATCH FIELD BRICK AND JAMB TO MATCH ACCENT BRICK. (REFER TO DOOR SCHEDULE).
- STOREFRONT: (REFER TO FLOOR PLAN FOR WINDOW TYPES).
- LINE OF FOUNDATION: (REFER TO FOUNDATION PLAN)
- STEEL BOLLARDS: FIELD PAINT "O'REILLY GREEN". (REFER TO FOUNDATION PLAN).
- HOSE BIB: (REFER TO PLUMBING PLAN).
- LIGHT FIXTURE: (REFER TO ELECTRICAL PLAN).
- NOT USED
- MECHANICAL UNIT: APPROXIMATE LOCATION (REFER TO MECHANICAL PLAN FOR EXACT LOCATION).
- MECHANICAL WALL PENETRATIONS: PROVIDE FRAMING, FLASHING, AND SEALANT AS REQUIRED. (REFER TO M.E.P. SHEETS).
- ROOF PIPING VENT: REFER TO DETAIL 5/A3.
- CONCRETE SPLASH BLOCK: INSTALL AT EACH DOWNSPOUT. FLUSH WEATHERPROOF.
- MASONRY CONTROL/EXPANSION JOINT: (MATCH MASONRY) PROVIDE SEALANT OVER 1/2" DIAMETER FOAM BACKER ROD. (REFER TO STRUCTURAL SHEETS).
- RUSTICATION JOINT: REFER TO DETAIL 6/A3.
- WOOD FENCE AND GATE: REFER TO DETAILS 11/C3 AND 12/C3.
- 18 GA. STAINLESS STEEL SCUPPER BY BUTLER MFG. CO. - INSTALL PER MFG'R INSTRUCTIONS - INSIDE OPENING WIDTH TO BE 1'-4". REFER TO DETAIL 9/A4.



**CRAIG A. SCHNEIDER, AIA**  
ARCHITECT

417-862-0558  
Fax: 417-862-9265  
e-mail: architect@estertyschneider.com

New O'Reilly Auto Parts Store

COLERAIN AVE.  
COLERAIN TOWNSHIP, OH



Corporate Office:  
233 South Patterson, Springfield, Mo 65802  
Phone: (417) 862-3333  
Fax: (417) 874-7112

COMM # 2814

DATE: 7-30-10

REVISION

DATE: