




Printed: 2 Aug 2010 at 4:16 pm

H:\GRE\0377A\0\0377SU2 2 Aug 2010 - 3:10 pm

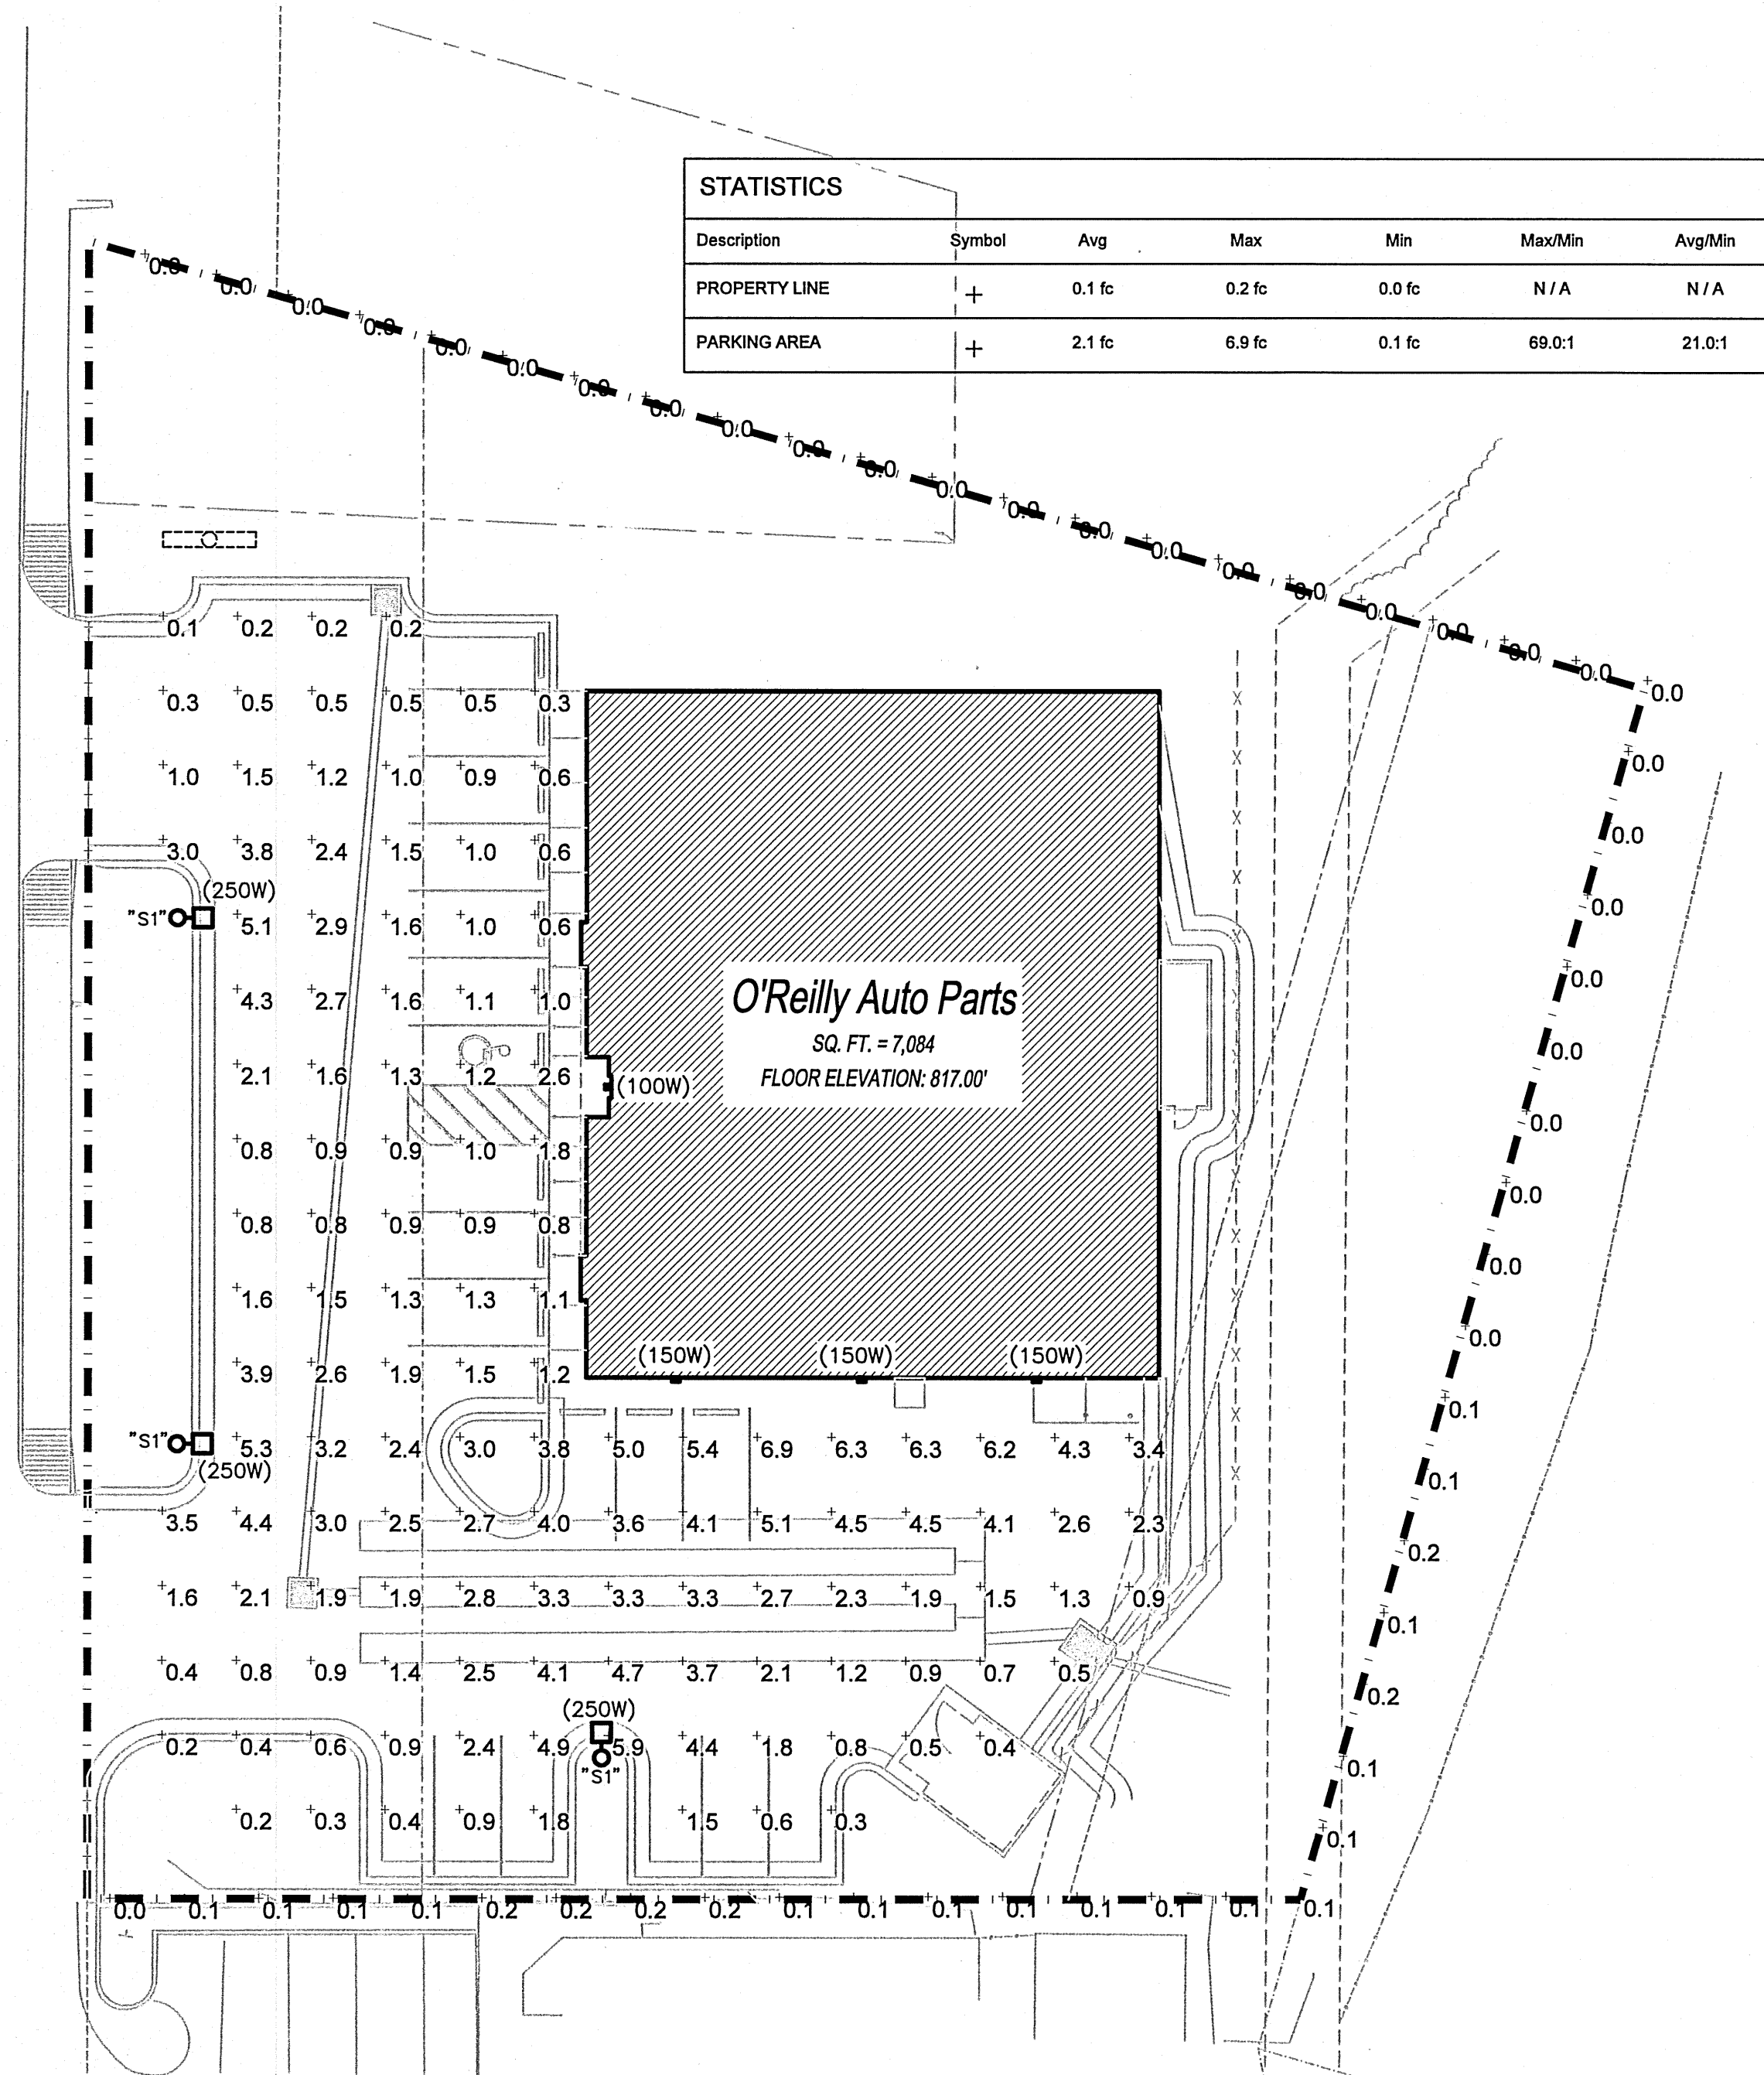


1
SU2 **SITE LIGHTING PLAN**
SCALE: 1"=20'
NORTH 
CONSTR. NORTH 



CRAIG A. SCHNEIDER, AIA
ARCHITECT
1736 East Sunshine, Suite 417
Springfield, Missouri 65804
417.562.0558
Fax: 417.562.3265
e-mail: architect@estertyschneider.com

New O'Reilly Auto Parts Store:
COLERAIN AVENUE
COLERAIN TOWNSHIP, OH

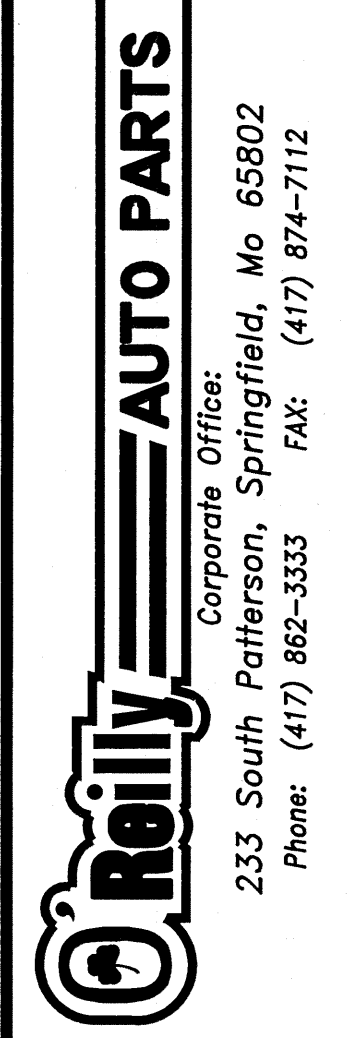

COMM # 2814

DATE: 7-30-10

REVISION
DATE: