
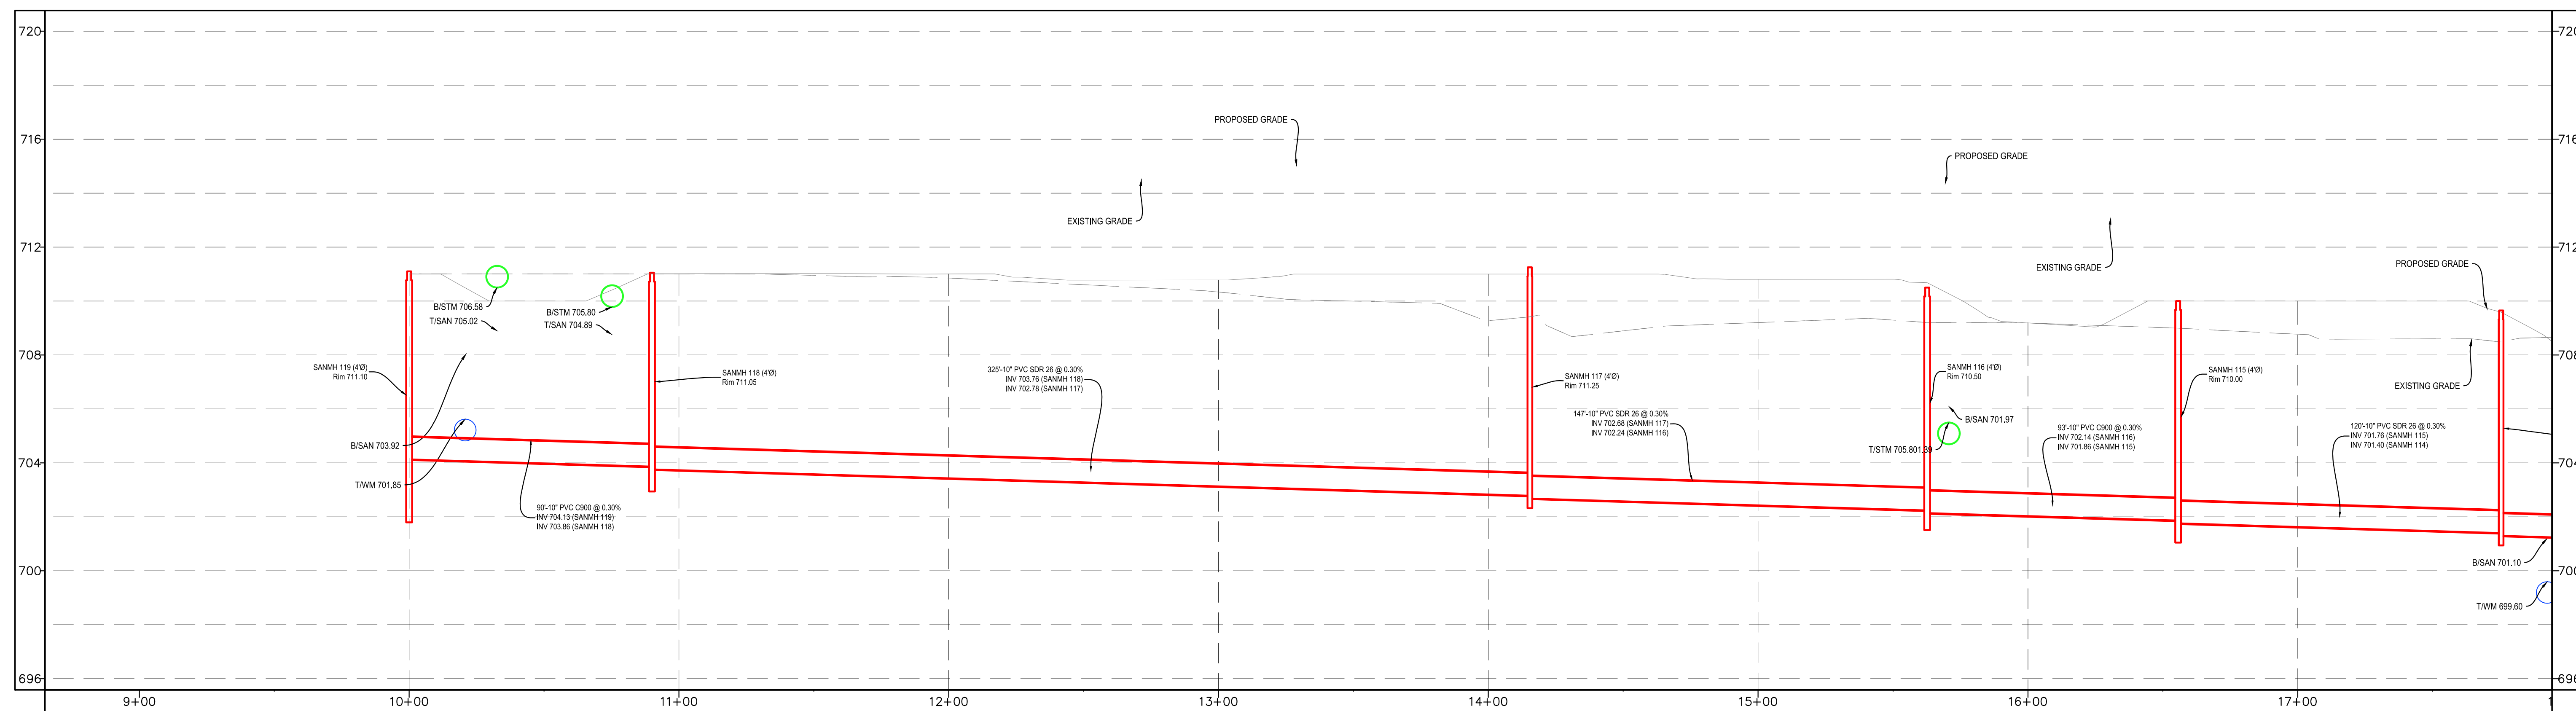


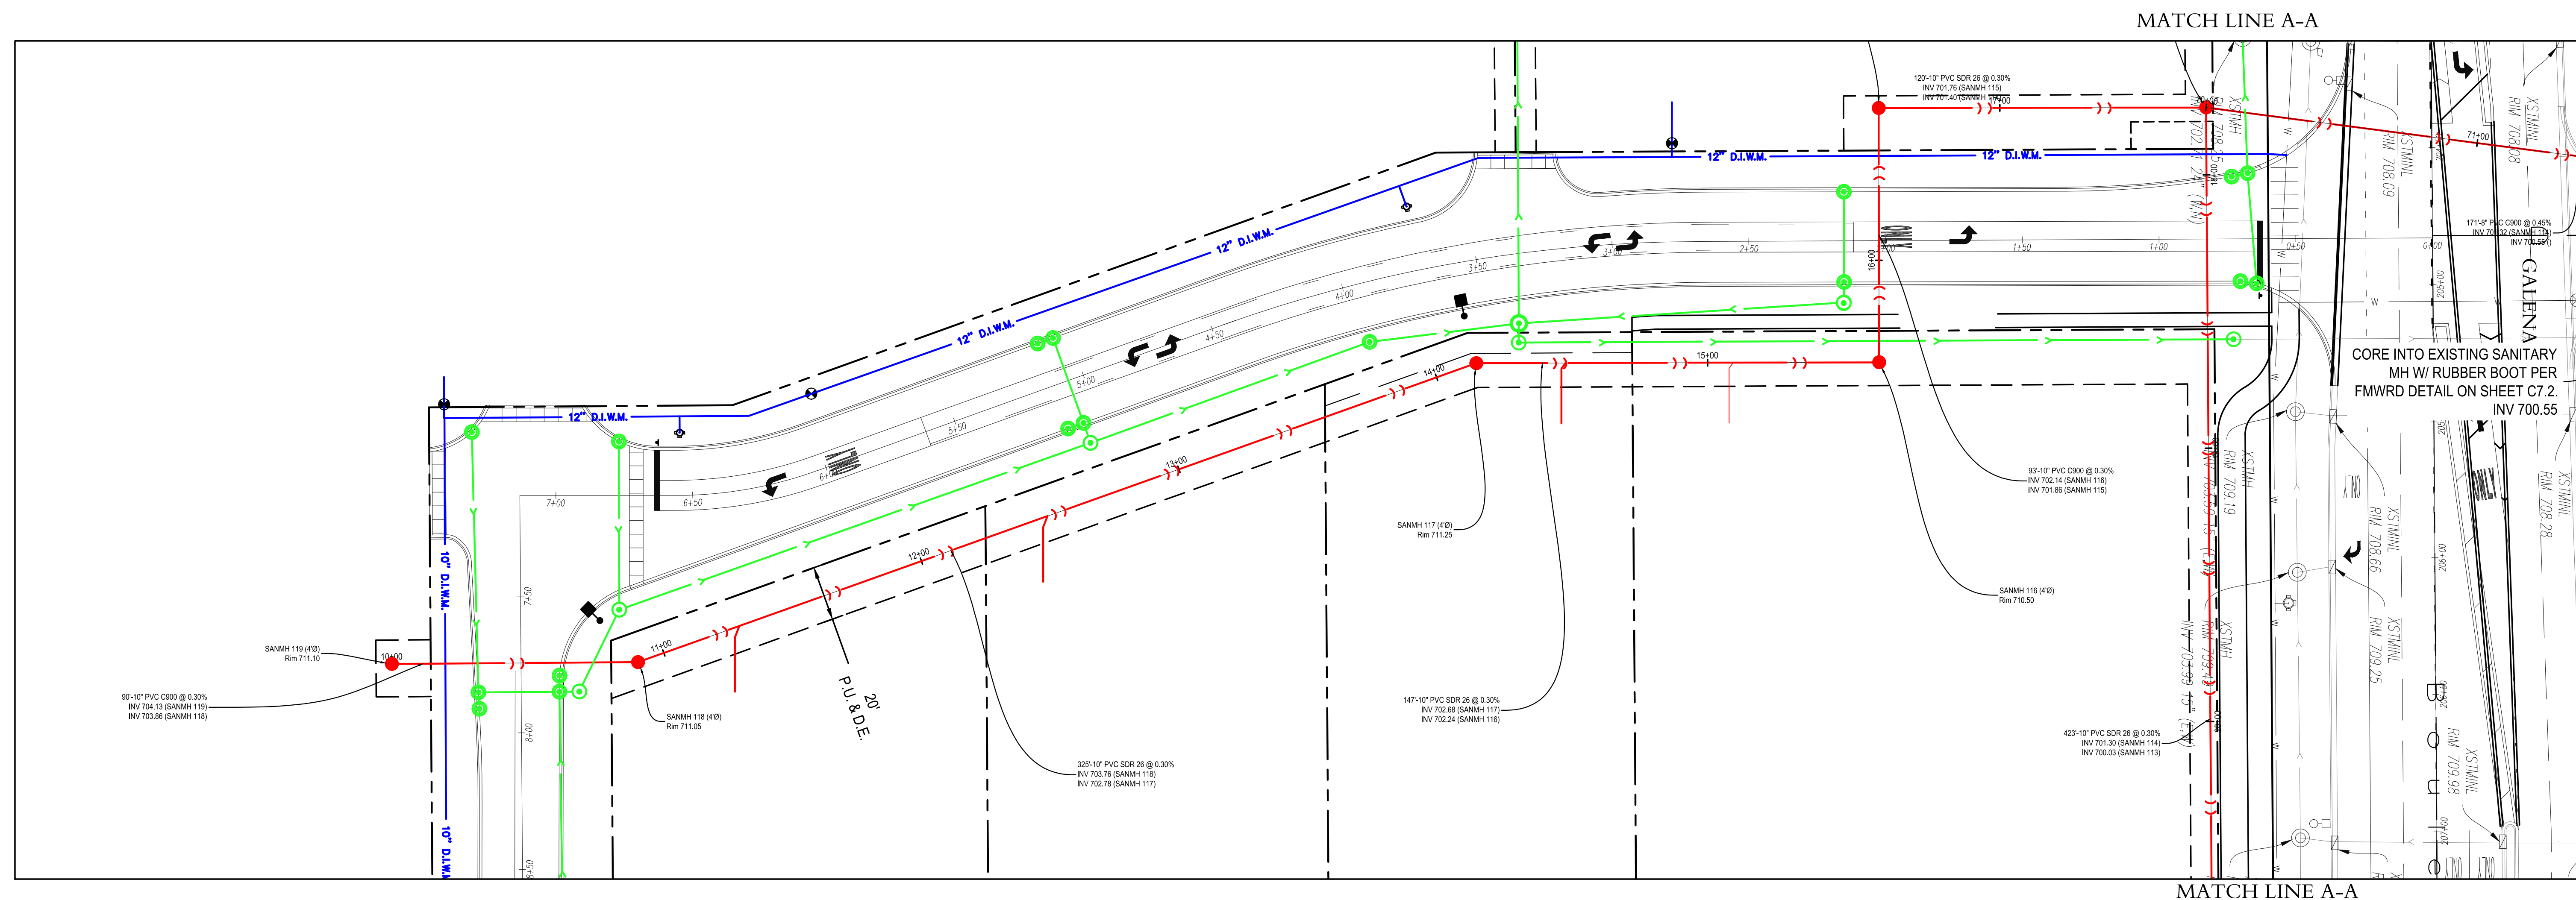

| R E V I S I O N S |         |                      |     |      |             |
|-------------------|---------|----------------------|-----|------|-------------|
|                   |         |                      |     |      |             |
| 8                 | 2/28/22 | PER VILLAGE COMMENTS |     |      |             |
| 3                 | 9/15/21 | PER VILLAGE COMMENTS |     |      |             |
| 2                 | 7/6/21  | PER VILLAGE COMMENTS |     |      |             |
| NO.               | DATE    | DESCRIPTION          | NO. | DATE | DESCRIPTION |

## SANITARY PLAN & PROFILE

|                                                                                          |
|------------------------------------------------------------------------------------------|
| PRAIRIE GROVE COMMONS UNIT TWO<br>SWC IL ROUTE 47 & GALENA BLVD<br>SUGAR GROVE, ILLINOIS |
|------------------------------------------------------------------------------------------|

HORIZONTAL SCALE: 1" = 30'  
VERTICAL SCALE: 1" = 3'



**CRAIG R. KNOCHÉ & ASSOCIATES**  
Civil Engineers, P.C.

1161 Commerce Drive • Geneva, IL 60134 • phone (630) 845-1270 • fax (630) 845-1275

- Civil Engineers
- Surveyors
- Land Planners

|         |            |
|---------|------------|
| DATE:   | 5/24/21    |
| FILE:   | 20-036 C30 |
| JOB NO: | 20-036     |

C3.3

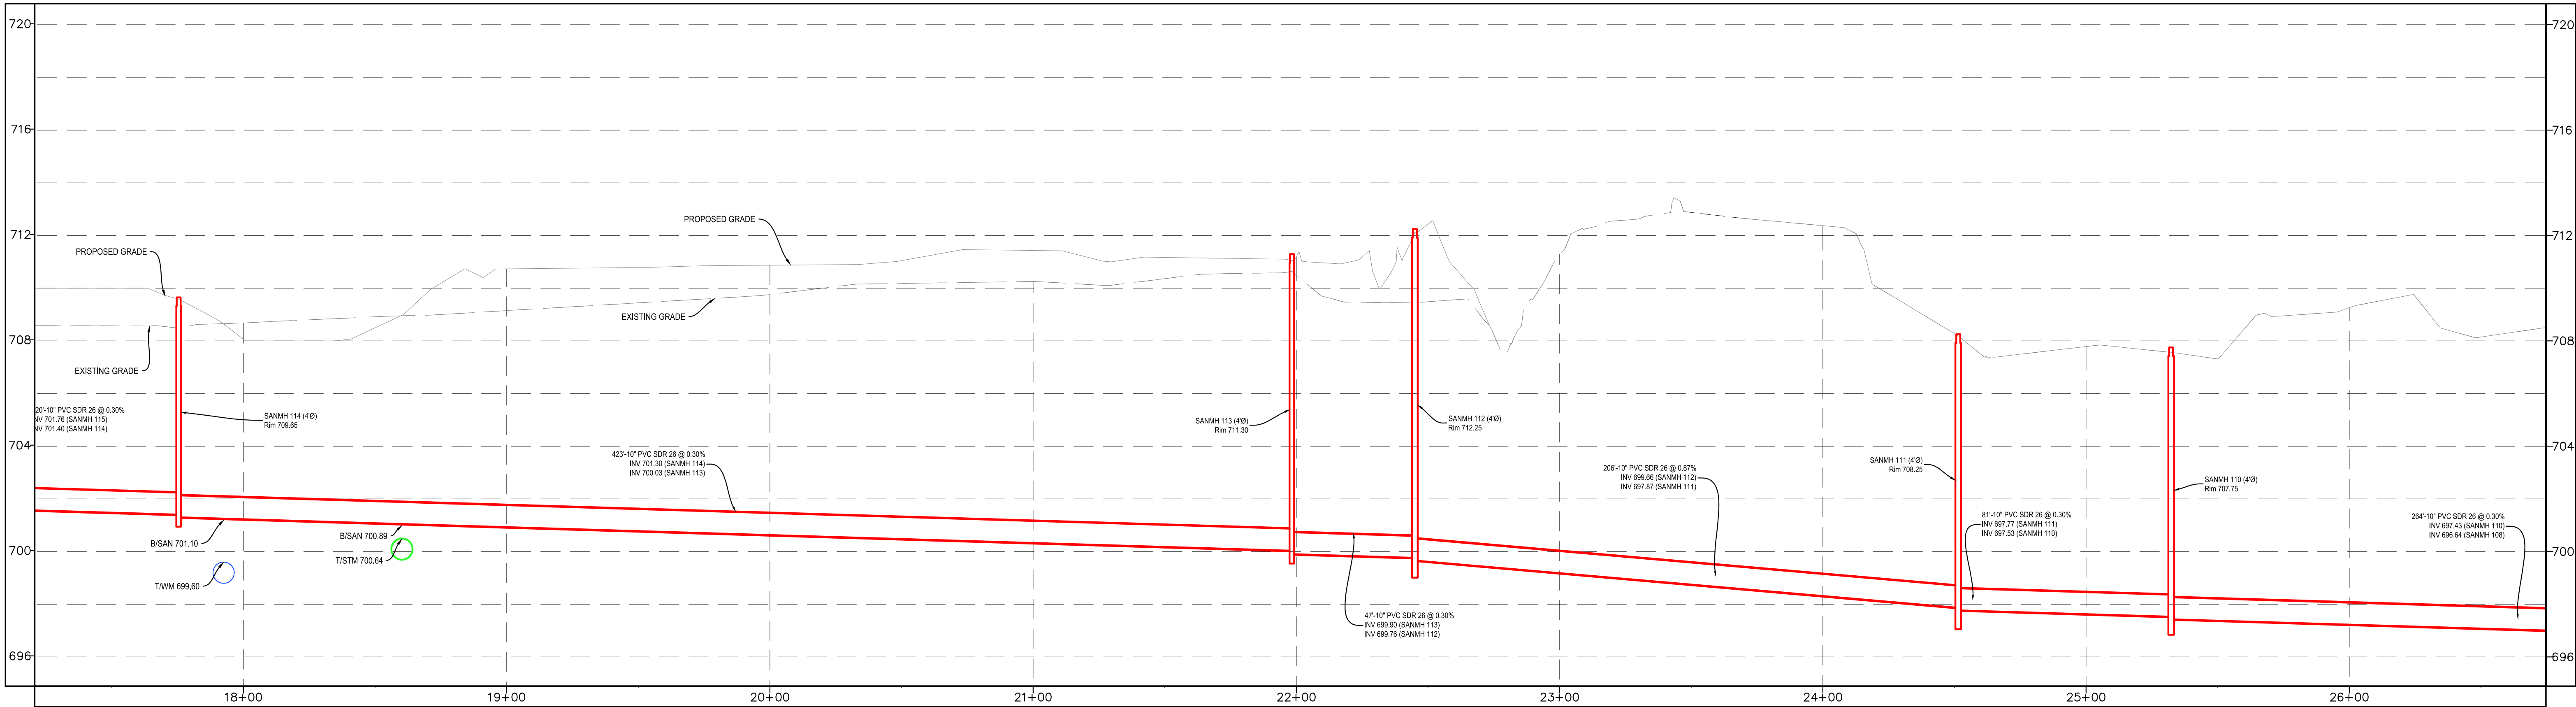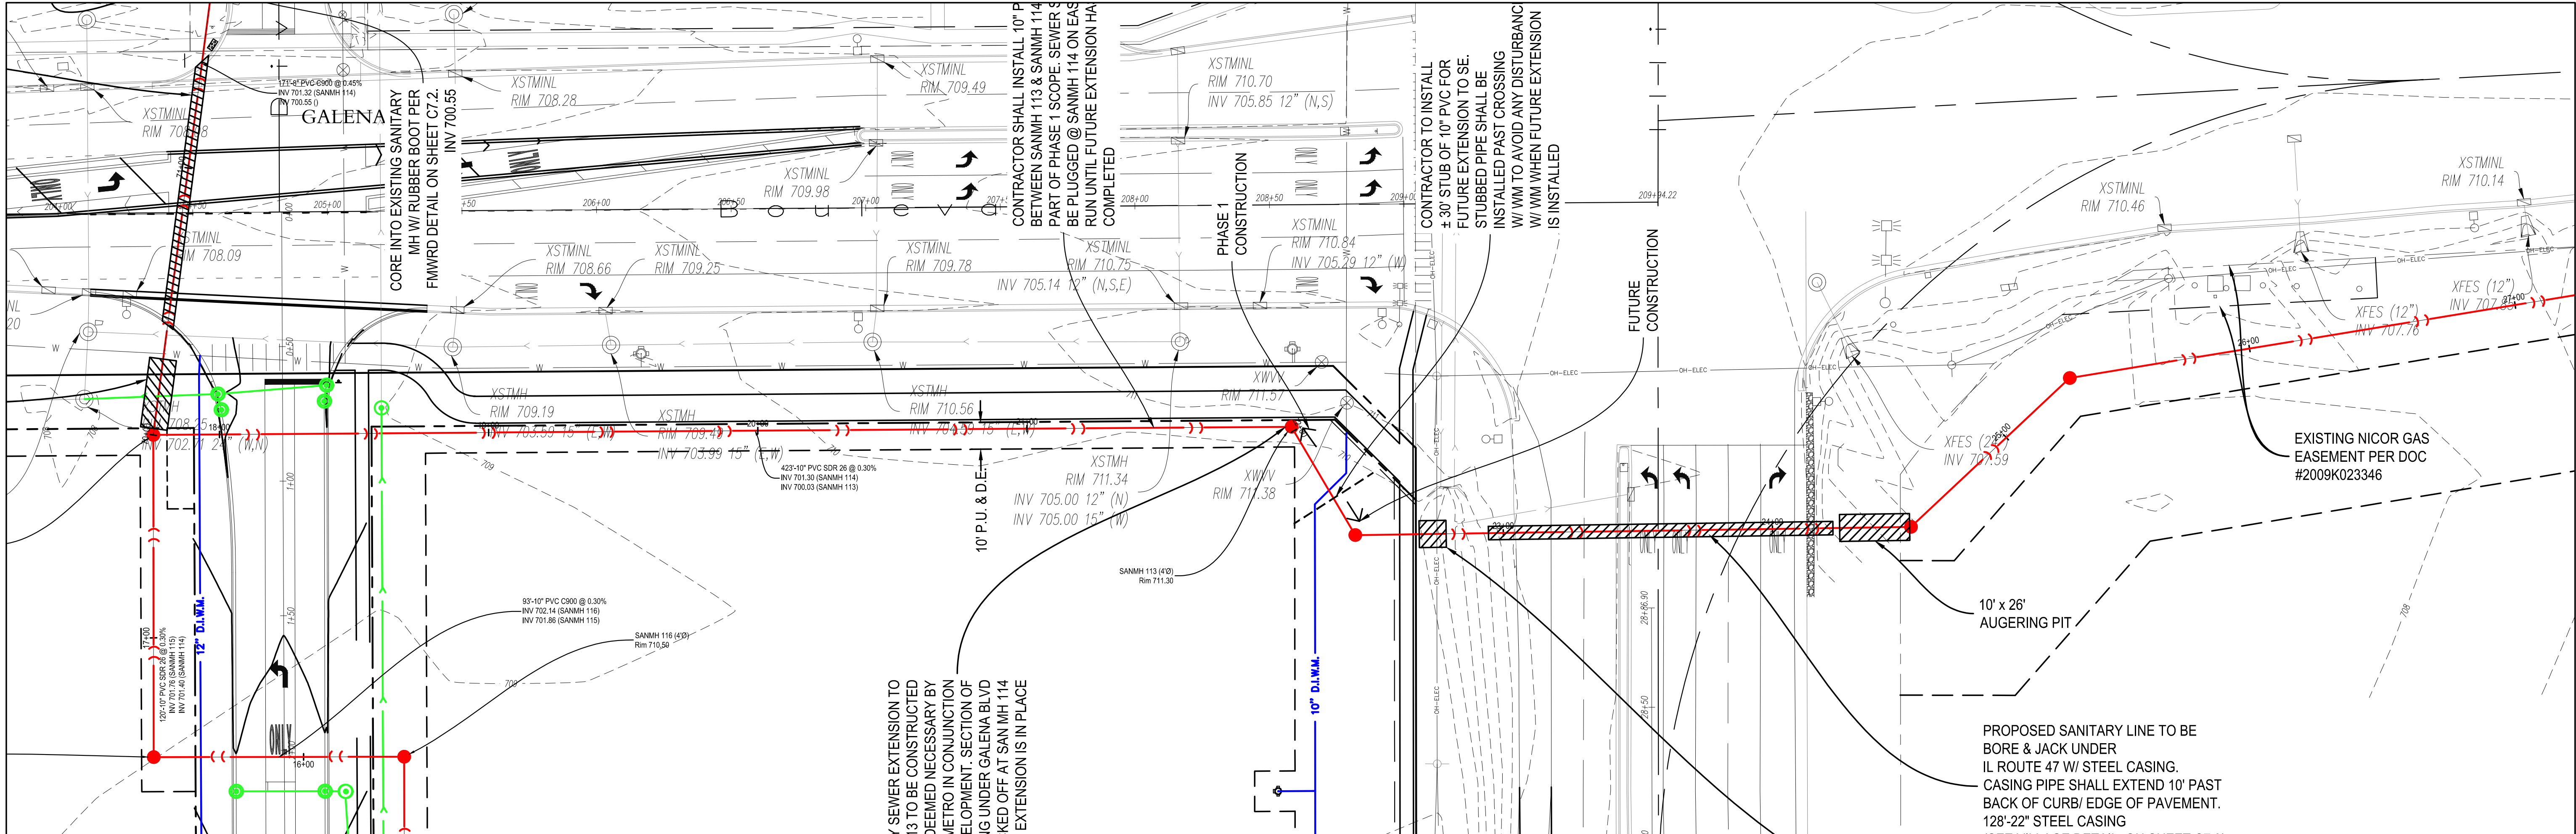

| REVISIONS |         |                      |     |      |             |
|-----------|---------|----------------------|-----|------|-------------|
| NO.       | DATE    | DESCRIPTION          | NO. | DATE | DESCRIPTION |
| 8         | 2/28/22 | PER VILLAGE COMMENTS |     |      |             |
| 3         | 9/15/21 | PER VILLAGE COMMENTS |     |      |             |
| 2         | 7/6/21  | PER VILLAGE COMMENTS |     |      |             |

# SANITARY PLAN & PROFILE

PRAIRIE GROVE COMMONS UNIT TWO  
SWC IL ROUTE 47 & GALENA BLVD  
SUGAR GROVE, ILLINOIS



HORIZONTAL SCALE: 1" = 30'  
VERTICAL SCALE: 1" = 3'

**Craig R. Knoche & Associates**  
Civil Engineers, P.C.  
1161 Commerce Drive • Geneva, IL 60134 • phone (630) 845-1270 • fax (630) 845-1275

- Civil Engineers
- Surveyors
- Land Planners

DATE: 5/24/21  
FILE: 20-036 C30  
JOB NO: 20-036

C3.4  
SHEET NO.

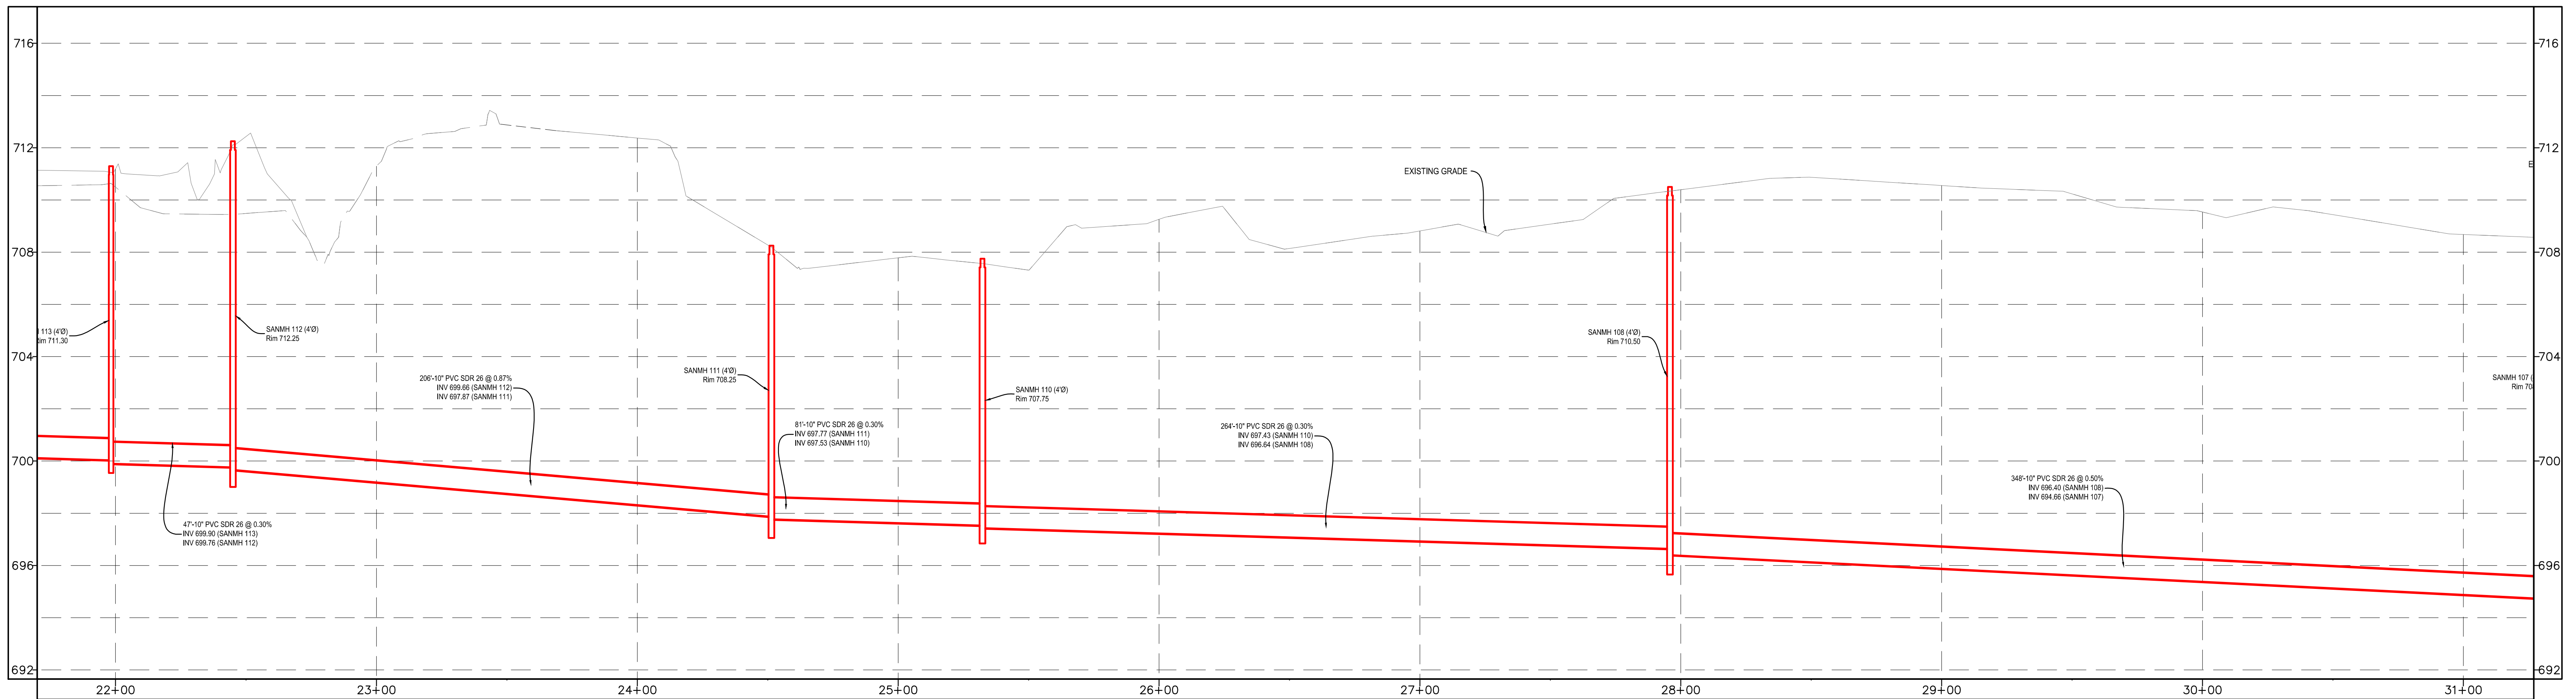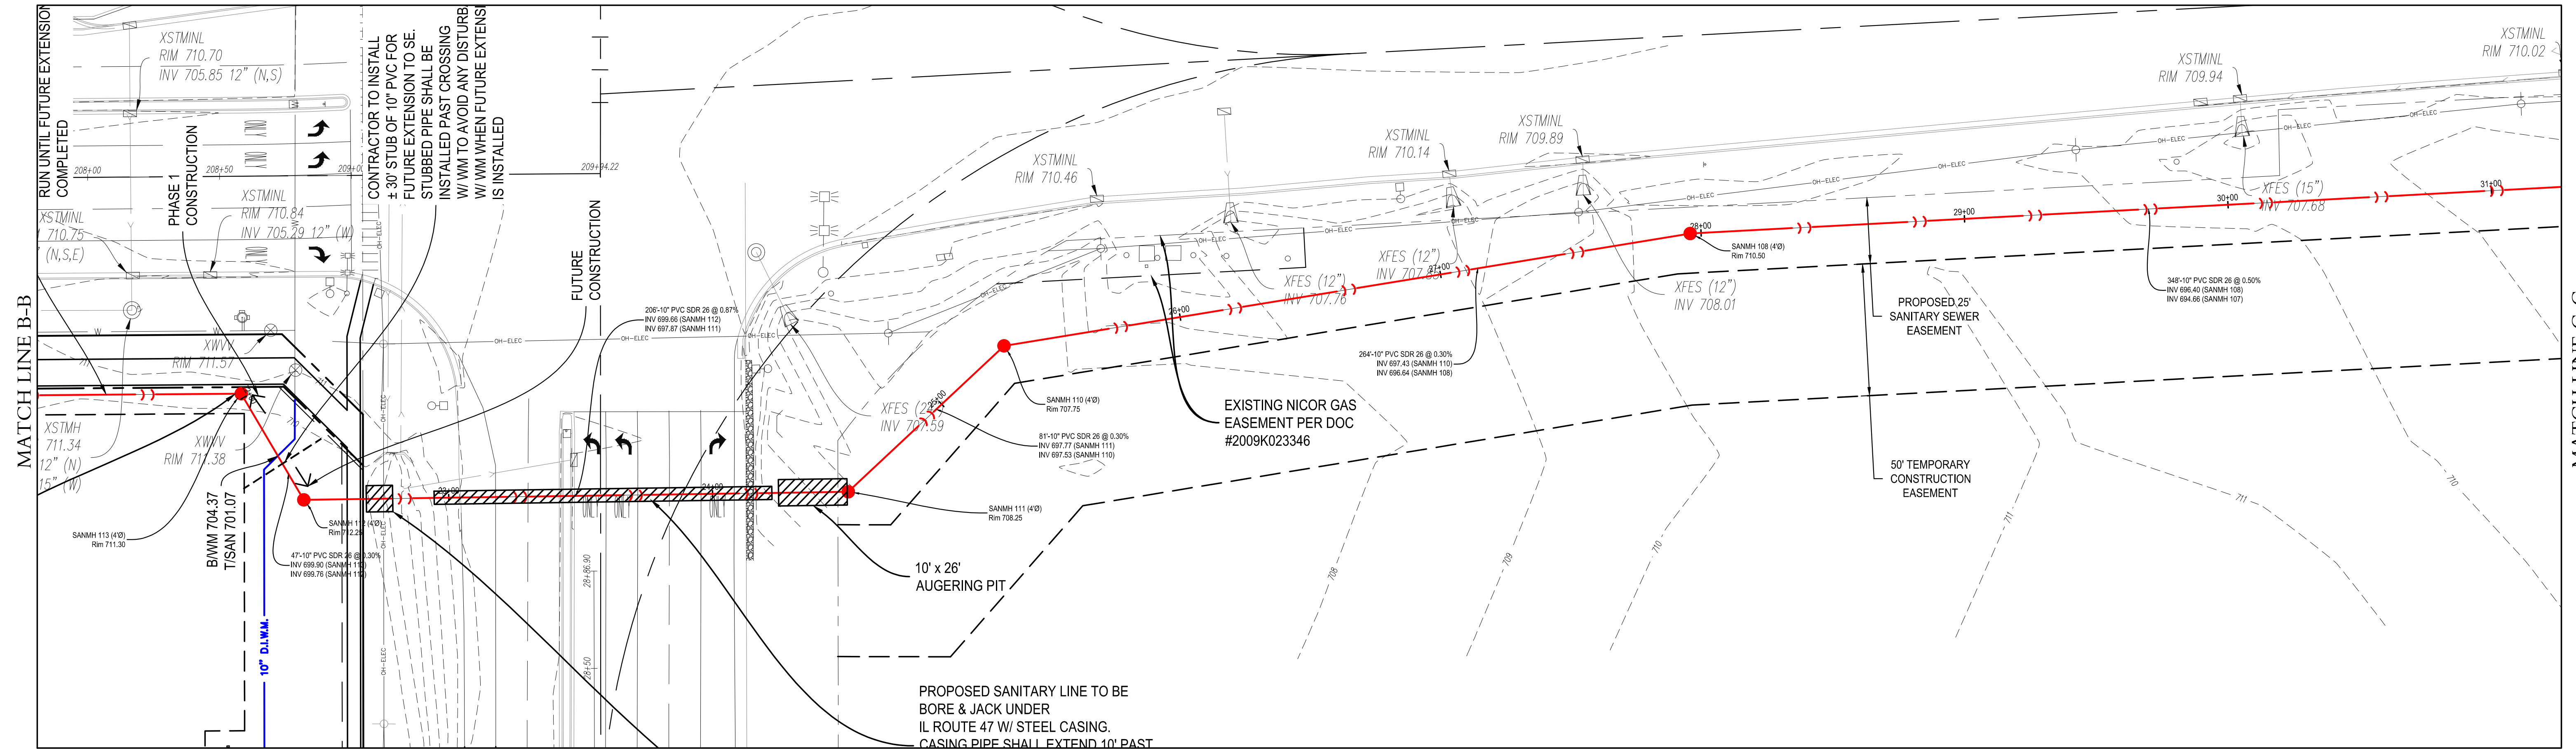

| REVISIONS |         |                      |     |      |
|-----------|---------|----------------------|-----|------|
| NO.       | DATE    | DESCRIPTION          | NO. | DATE |
| 3         | 9/15/21 | PER VILLAGE COMMENTS |     |      |
| 2         | 7/6/21  | PER VILLAGE COMMENTS |     |      |

## SANITARY PLAN & PROFILE



PRAIRIE GROVE COMMONS UNIT TWO  
SWC IL ROUTE 47 & GALENA BLVD  
SUGAR GROVE, ILLINOIS

HORIZONTAL SCALE: 1" = 30'  
VERTICAL SCALE: 1" = 3'

**Craig R. Knoche & Associates** Civil Engineers  
1161 Commerce Drive • Geneva, IL 60134 • phone (630) 845-1270 • fax (630) 845-1275

DATE: 5/24/21  
FILE: 20-036 C30  
JOB NO: 20-036  
SHEET NO.

C3.5

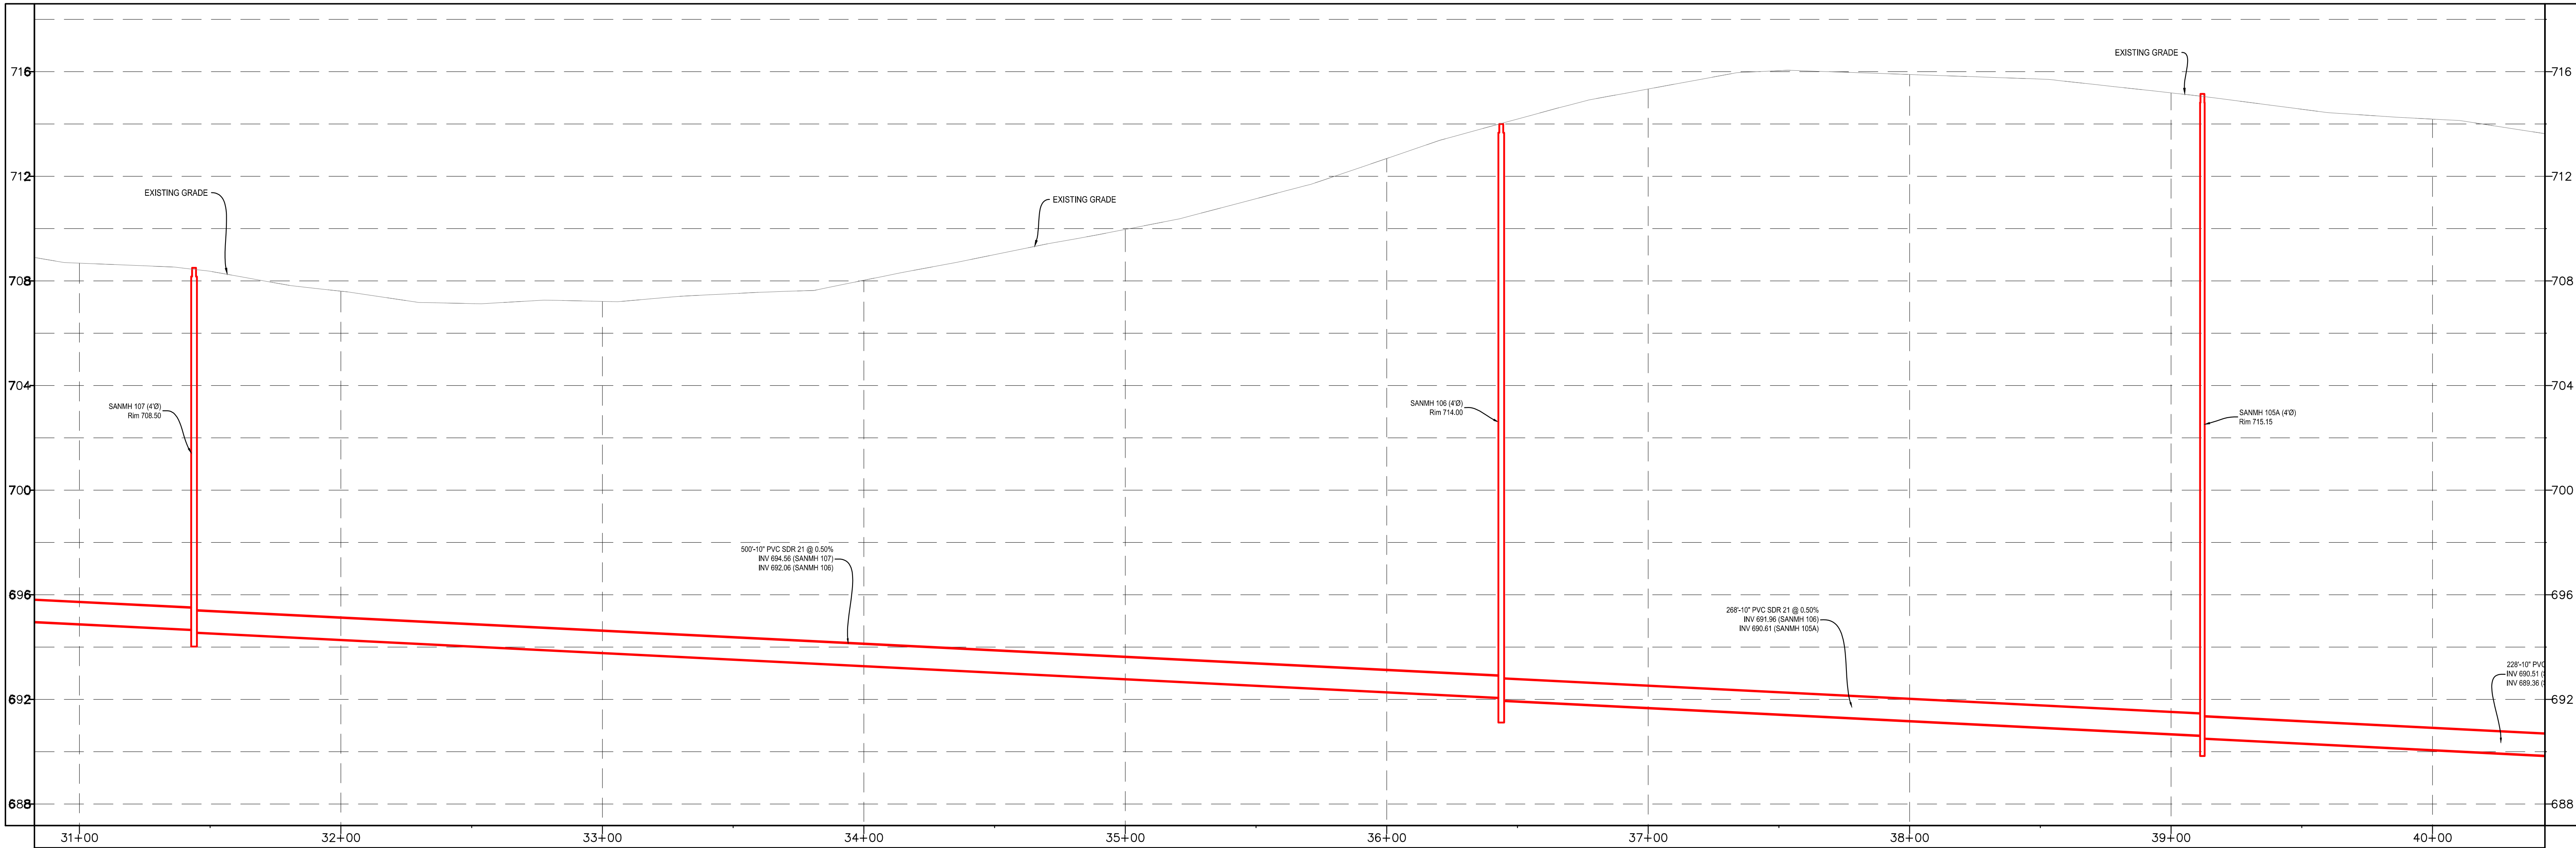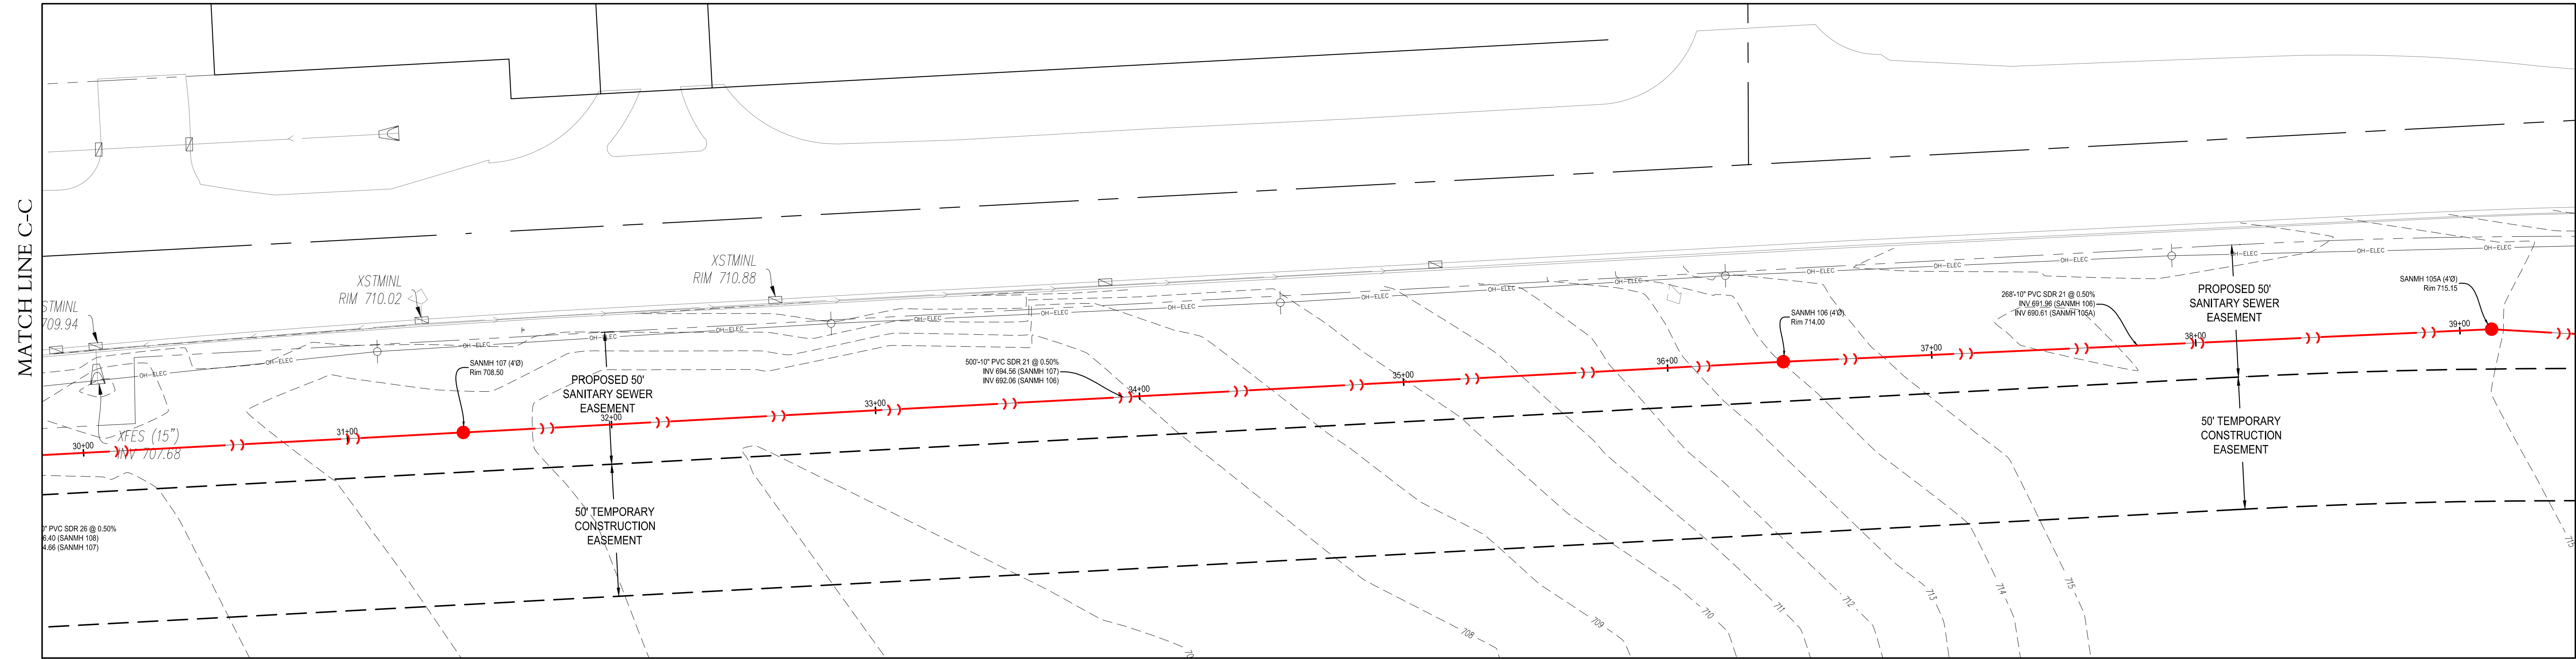

| REVISIONS |         |                      |     |      |             |  |
|-----------|---------|----------------------|-----|------|-------------|--|
| NO.       | DATE    | DESCRIPTION          | NO. | DATE | DESCRIPTION |  |
| 3         | 9/15/21 | PER VILLAGE COMMENTS |     |      |             |  |
| 2         | 7/6/21  | PER VILLAGE COMMENTS |     |      |             |  |

# SANITARY PLAN & PROFILE

PRAIRIE GROVE COMMONS UNIT TWO  
SWC IL ROUTE 47 & GALENA BLVD  
SUGAR GROVE, ILLINOIS



HORIZONTAL SCALE: 1" = 30'  
VERTICAL SCALE: 1" = 3'

**Craig R. Knoche & Associates** • Civil Engineers  
• Surveyors  
• Land Planners  
1161 Commerce Drive • Geneva, IL 60134 • phone (630) 845-1270 • fax (630) 845-1275

DATE: 5/24/21  
FILE: 20-036 C30  
JOB NO: 20-036

C3.6  
SHEET NO.



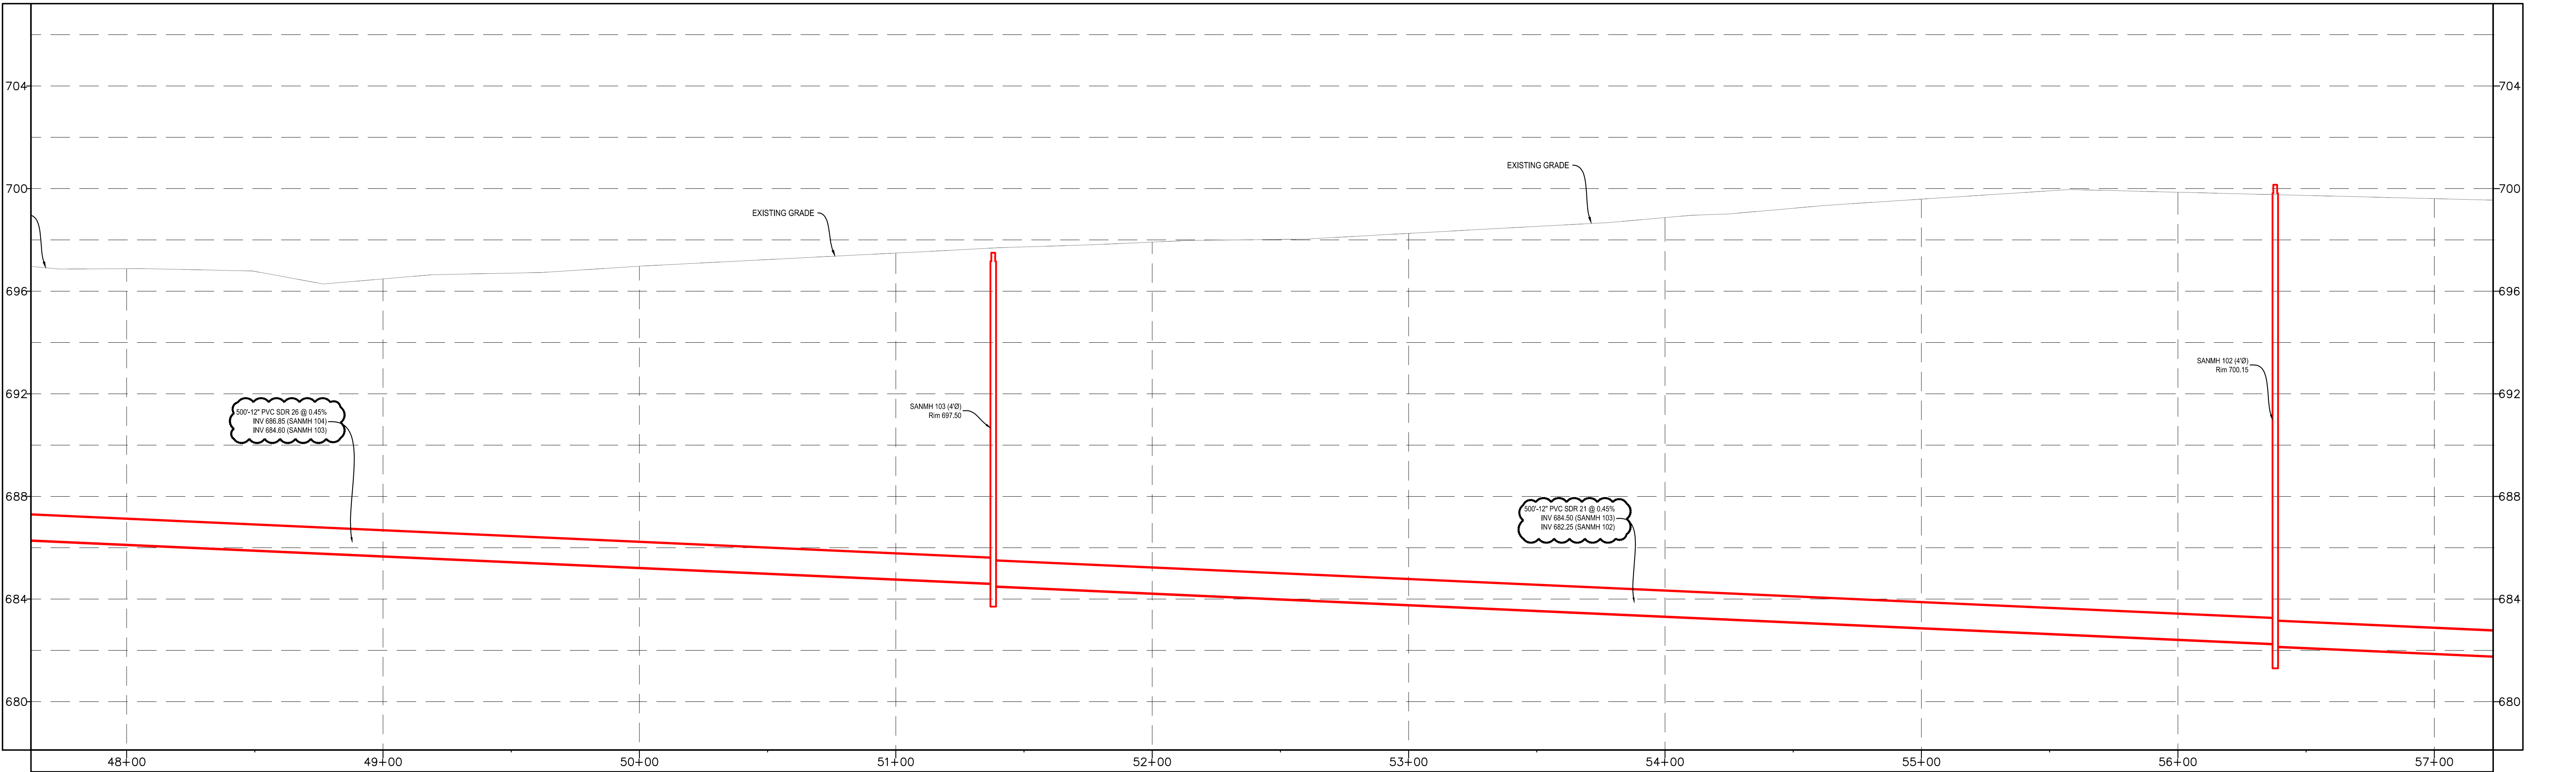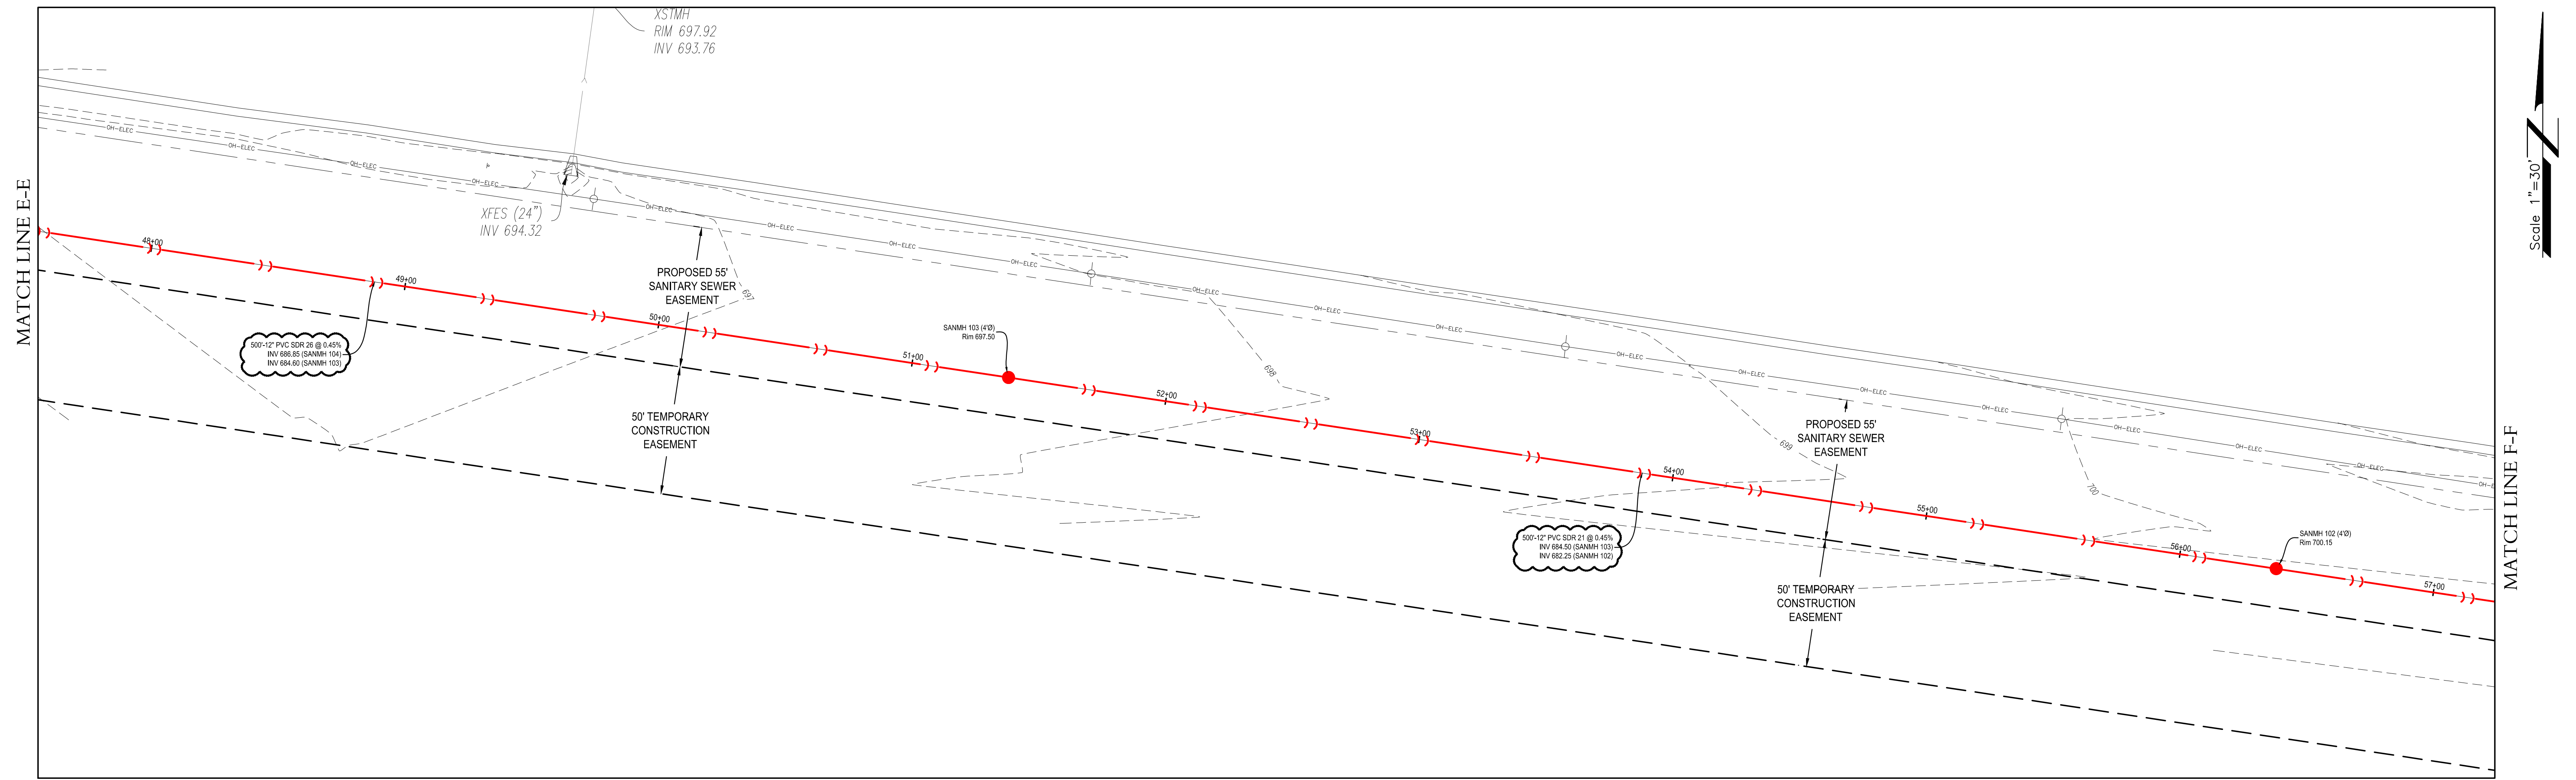

| R E V I S I O N S |         |                      |     |      |
|-------------------|---------|----------------------|-----|------|
| NO.               | DATE    | DESCRIPTION          | NO. | DATE |
| 7                 | 2/2/22  | PER SAN. REVISIONS   |     |      |
| 3                 | 9/15/21 | PER VILLAGE COMMENTS |     |      |
| 2                 | 7/6/21  | PER VILLAGE COMMENTS |     |      |



SANITARY  
PLAN & PROFILE

PRAIRIE GROVE COMMONS UNIT TWO  
SWC IL ROUTE 47 & GALENA BLVD  
SUGAR GROVE, ILLINOIS

HORIZONTAL SCALE: 1" = 30'  
VERTICAL SCALE: 1" = 3'

**Craig R. Knoche & Associates** • Civil Engineers  
• Surveyors  
• Land Planners  
1161 Commerce Drive • Geneva, IL 60134 • phone (630) 845-1270 • fax (630) 845-1275

DATE: 5/24/21  
FILE: 20-036 C30  
JOB NO: 20-036  
SHEET NO. C3.8

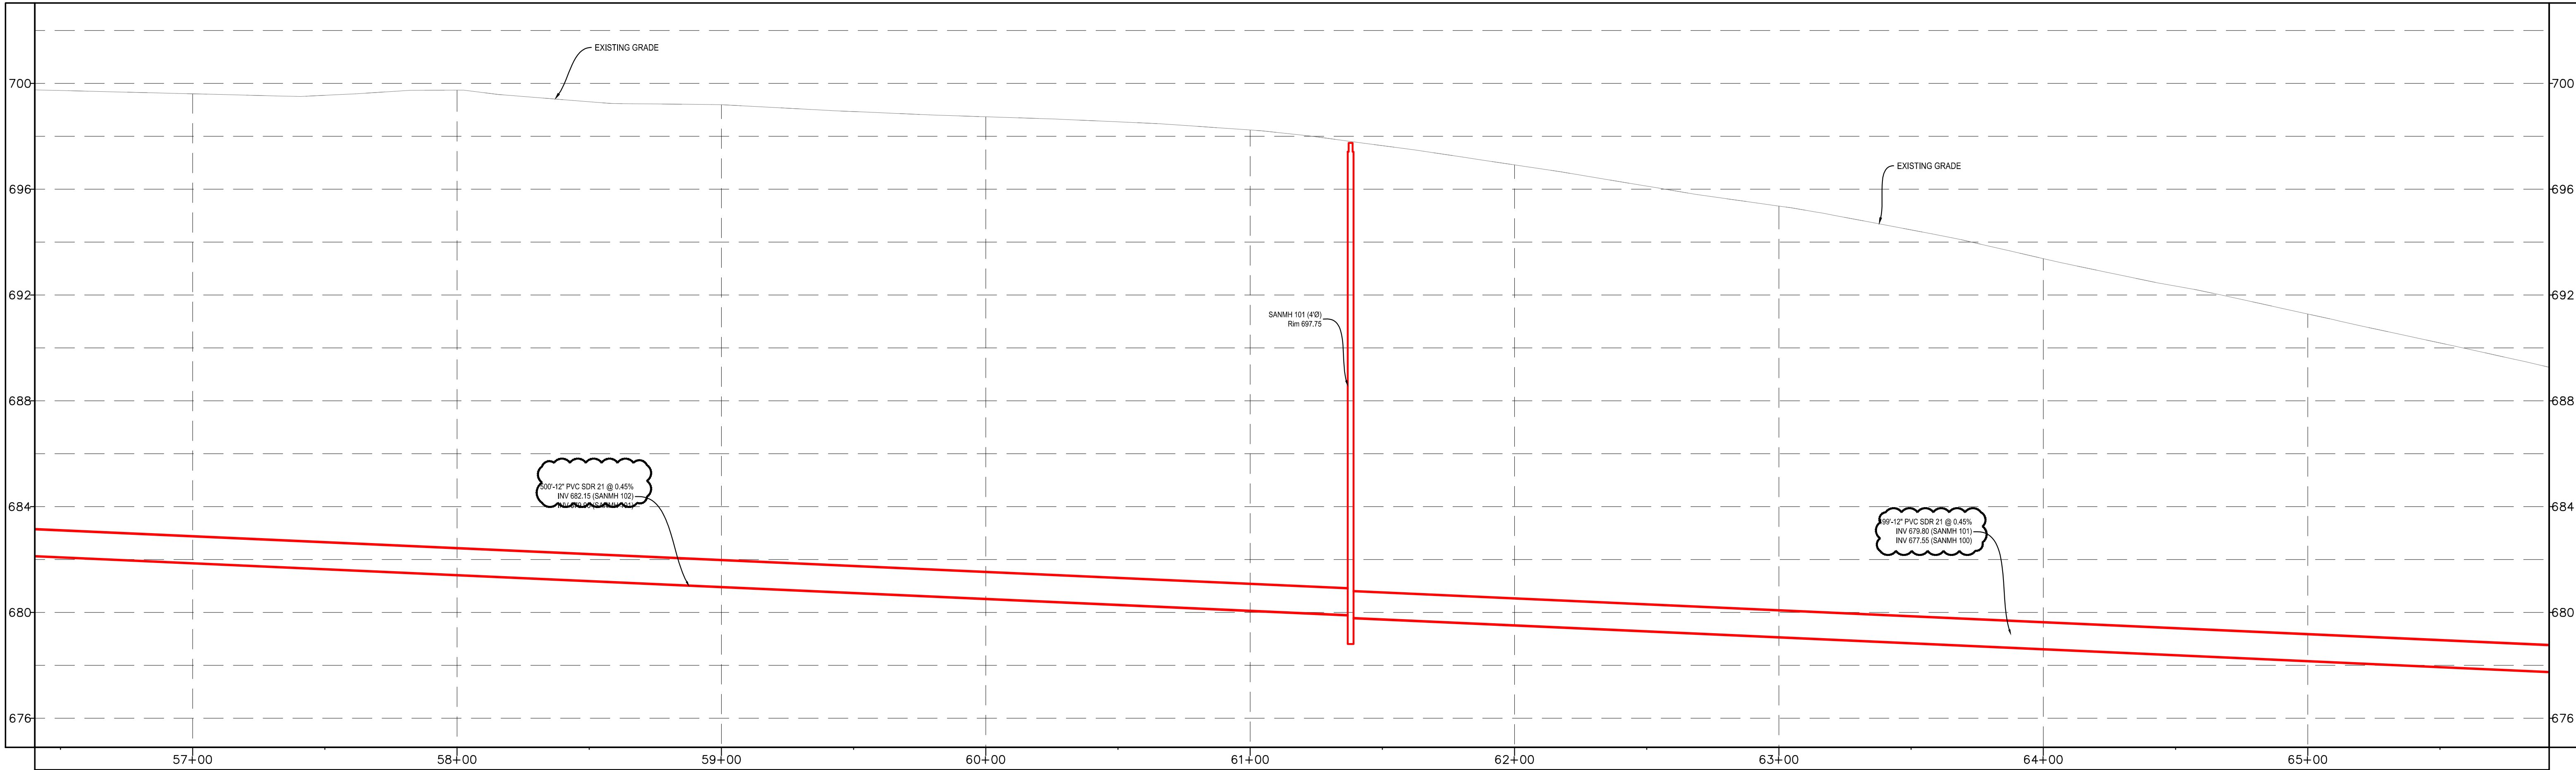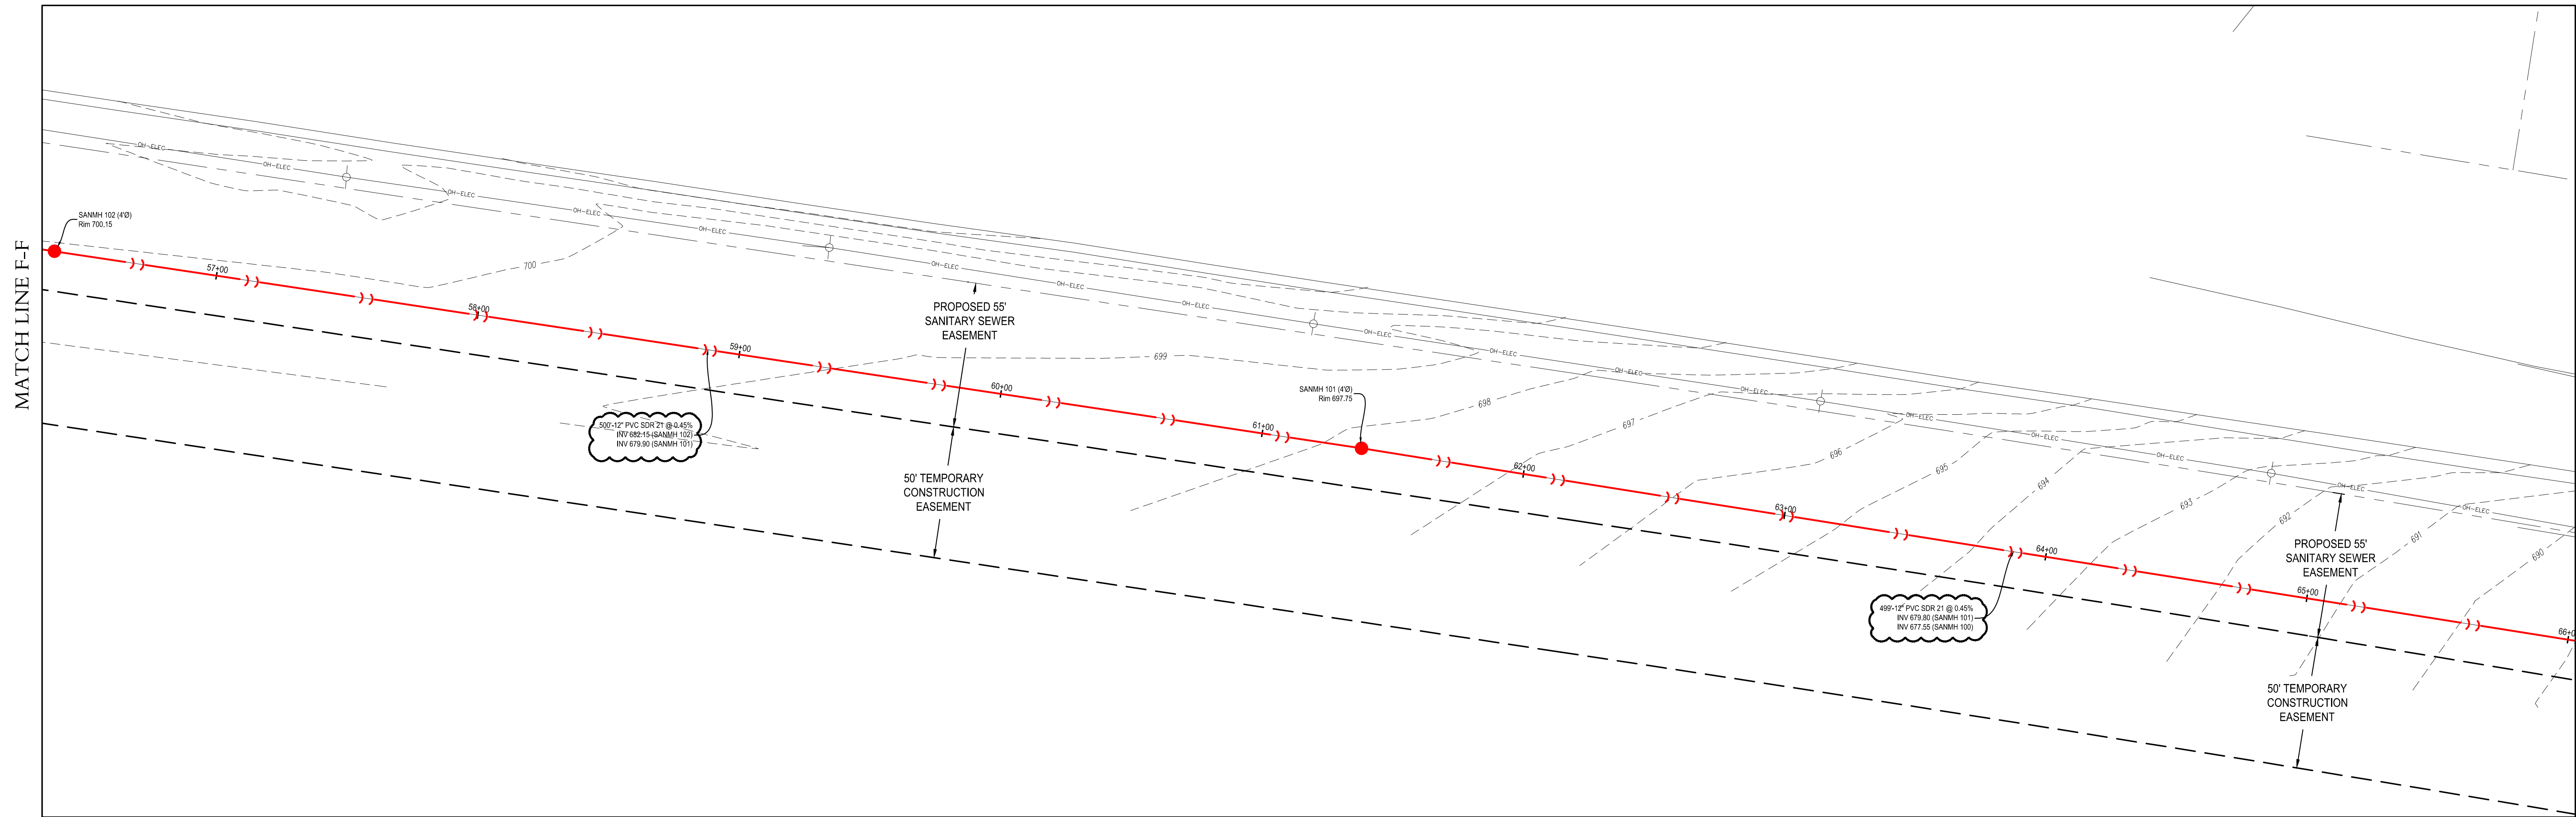

| REVISIONS |         |                      |     |      |
|-----------|---------|----------------------|-----|------|
| NO.       | DATE    | DESCRIPTION          | NO. | DATE |
| 7         | 2/2/22  | PER SAN. REVISIONS   |     |      |
| 3         | 9/15/21 | PER VILLAGE COMMENTS |     |      |
| 2         | 7/6/21  | PER VILLAGE COMMENTS |     |      |

# SANITARY PLAN & PROFILE



PRAIRIE GROVE COMMONS UNIT TWO  
SWC IL ROUTE 47 & GALENA BLVD  
SUGAR GROVE, ILLINOIS

HORIZONTAL SCALE: 1" = 30'  
VERTICAL SCALE: 1" = 3'

**Craig R. Knoche & Associates** *Civil Engineers*  
*Surveyors*  
*Land Planners*  
1161 Commerce Drive • Geneva, IL 60134 • phone (630) 845-1270 • fax (630) 845-1275

DATE: 5/24/21  
FILE: 20-036 C30  
JOB NO: 20-036

C3.9  
SHEET NO.

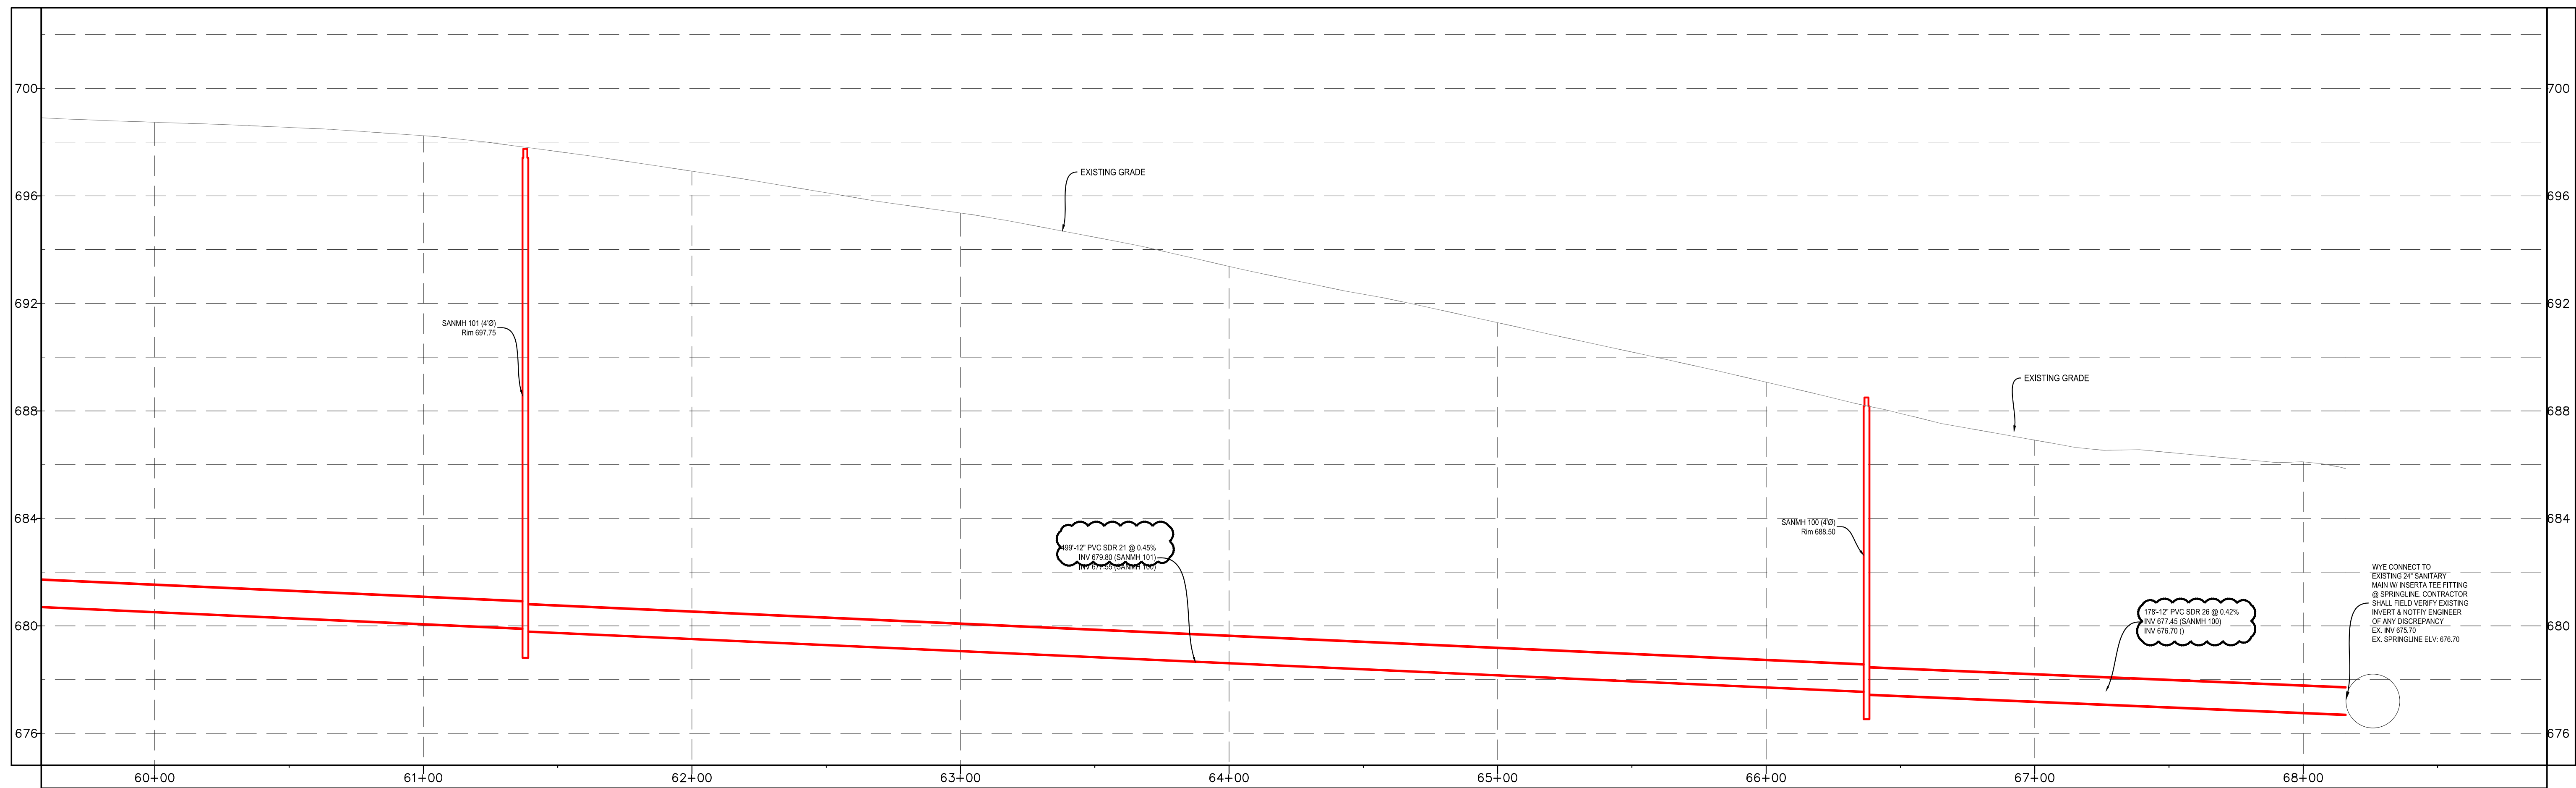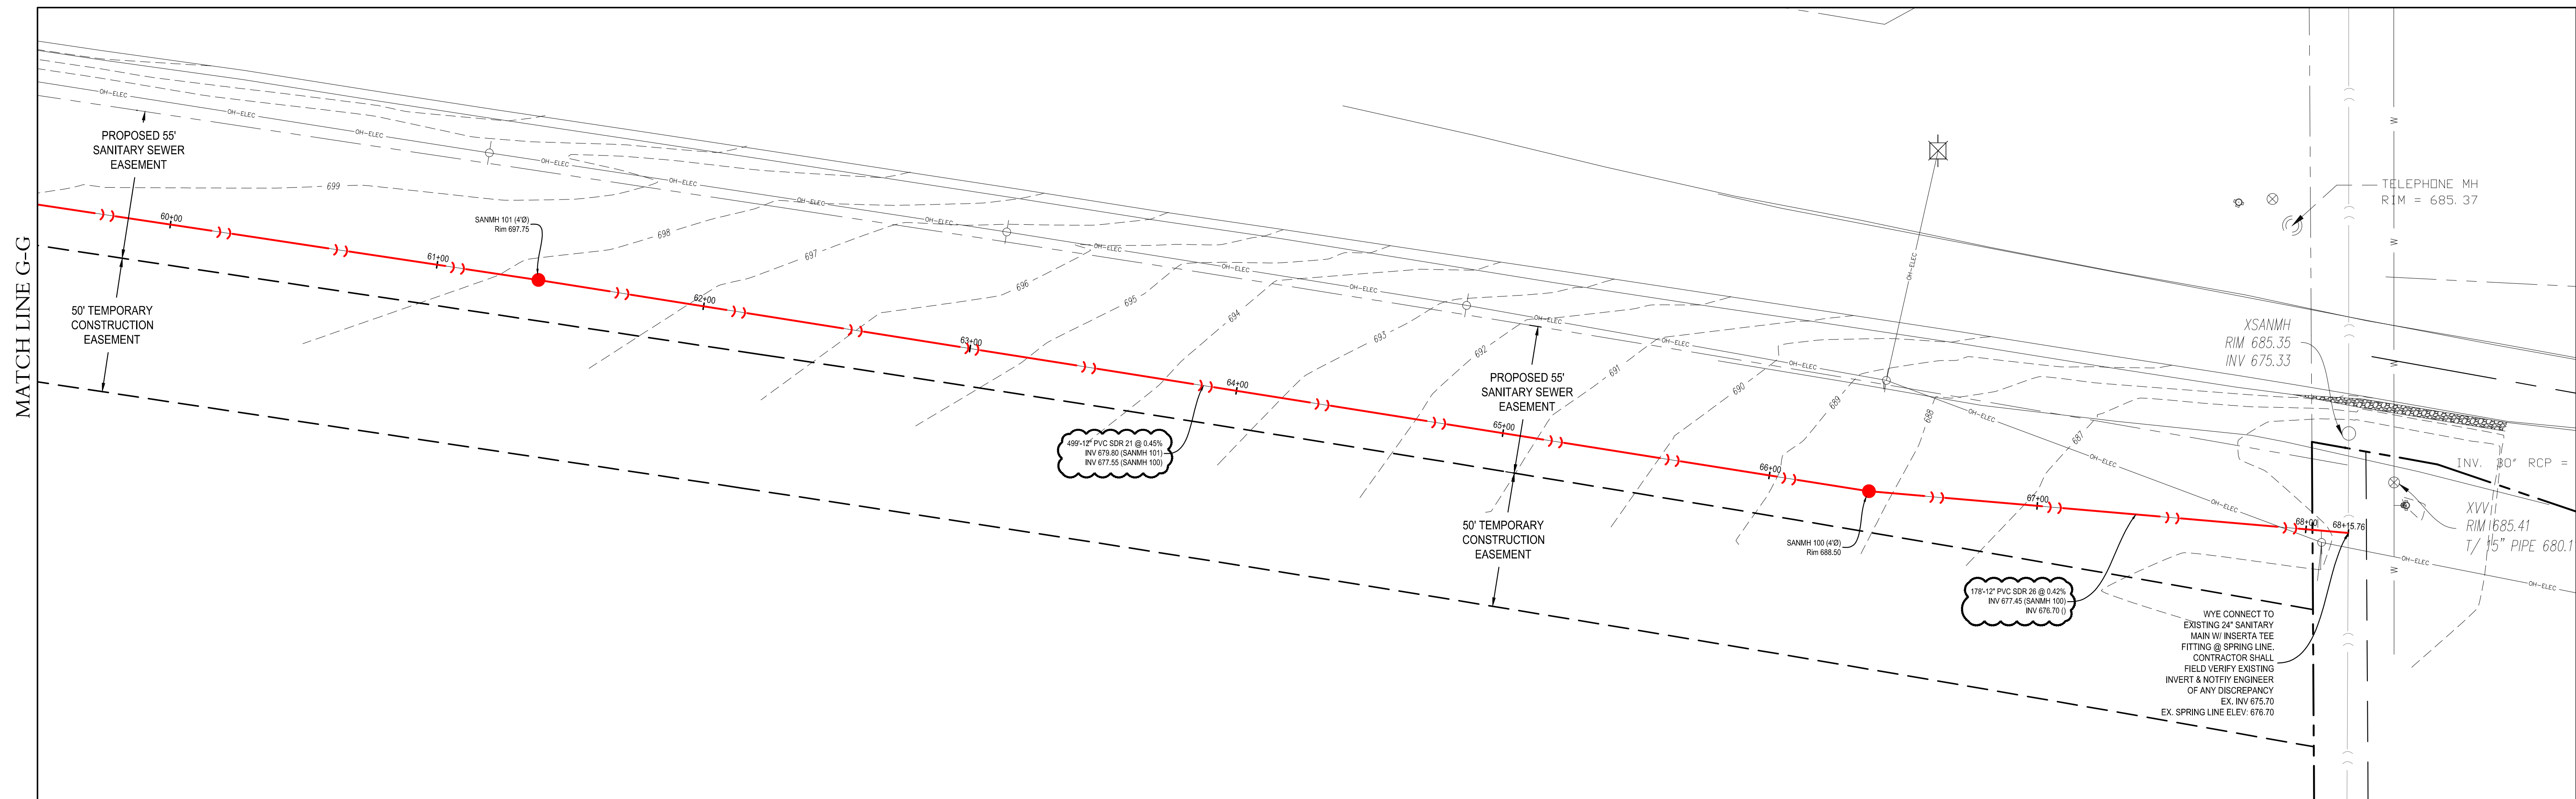

| REVISIONS |         |                      |     |      |             |  |  |
|-----------|---------|----------------------|-----|------|-------------|--|--|
| NO.       | DATE    | DESCRIPTION          | NO. | DATE | DESCRIPTION |  |  |
| 7         | 2/2/22  | PER SAN. REVISIONS   |     |      |             |  |  |
| 3         | 9/15/21 | PER VILLAGE COMMENTS |     |      |             |  |  |
| 2         | 7/6/21  | PER VILLAGE COMMENTS |     |      |             |  |  |

# SANITARY PLAN & PROFILE

PRAIRIE GROVE COMMONS UNIT TWO  
SWC IL ROUTE 47 & GALENA BLVD  
SUGAR GROVE, ILLINOIS

HORIZONTAL SCALE: 1" = 30'  
VERTICAL SCALE: 1" = 3'

**Craig R. Knoche & Associates** *Civil Engineers, P.C.*  
1161 Commerce Drive • Geneva, IL 60134 • phone (630) 845-1270 • fax (630) 845-1275

DATE: 5/24/21  
FILE: 20-036 C30  
JOB NO: 20-036

C3.10  
SHEET NO.